



Visual Concepts Lighting, Inc.
4655 Ruffner Street, - ste. #220
San Diego, Ca
92117
tel: 858-278-4503
email: kperez@visualconcepts-inc.com

Owner:
BLACK STAR
FINANCIAL

20201 SW Birch Street
Suite 100
Newport Beach, CA 92660
tel: 949-252-1122
email: rdorame@mastercraftresidential.com

Project:
**GOLD FLORA
FARMS**


19th street & North Indian Cyn. Dr.
Desert Hot springs, CA.

Consultants:
CIVIL MDS
STRUCTURAL
MECHANICAL
PLUMBING
ELECTRICAL Visual Concepts Lighting
LANDSCAPE RGA Landscape Arch.
FIRE PROTECTION
SOILS ENGINEER

Title: **LIGHTING PLAN 1**

Project Number: MRC16/11291
Drawn by: K.P.SR.
Date: 12/20/13
Revision:

Sheet:
EL-2

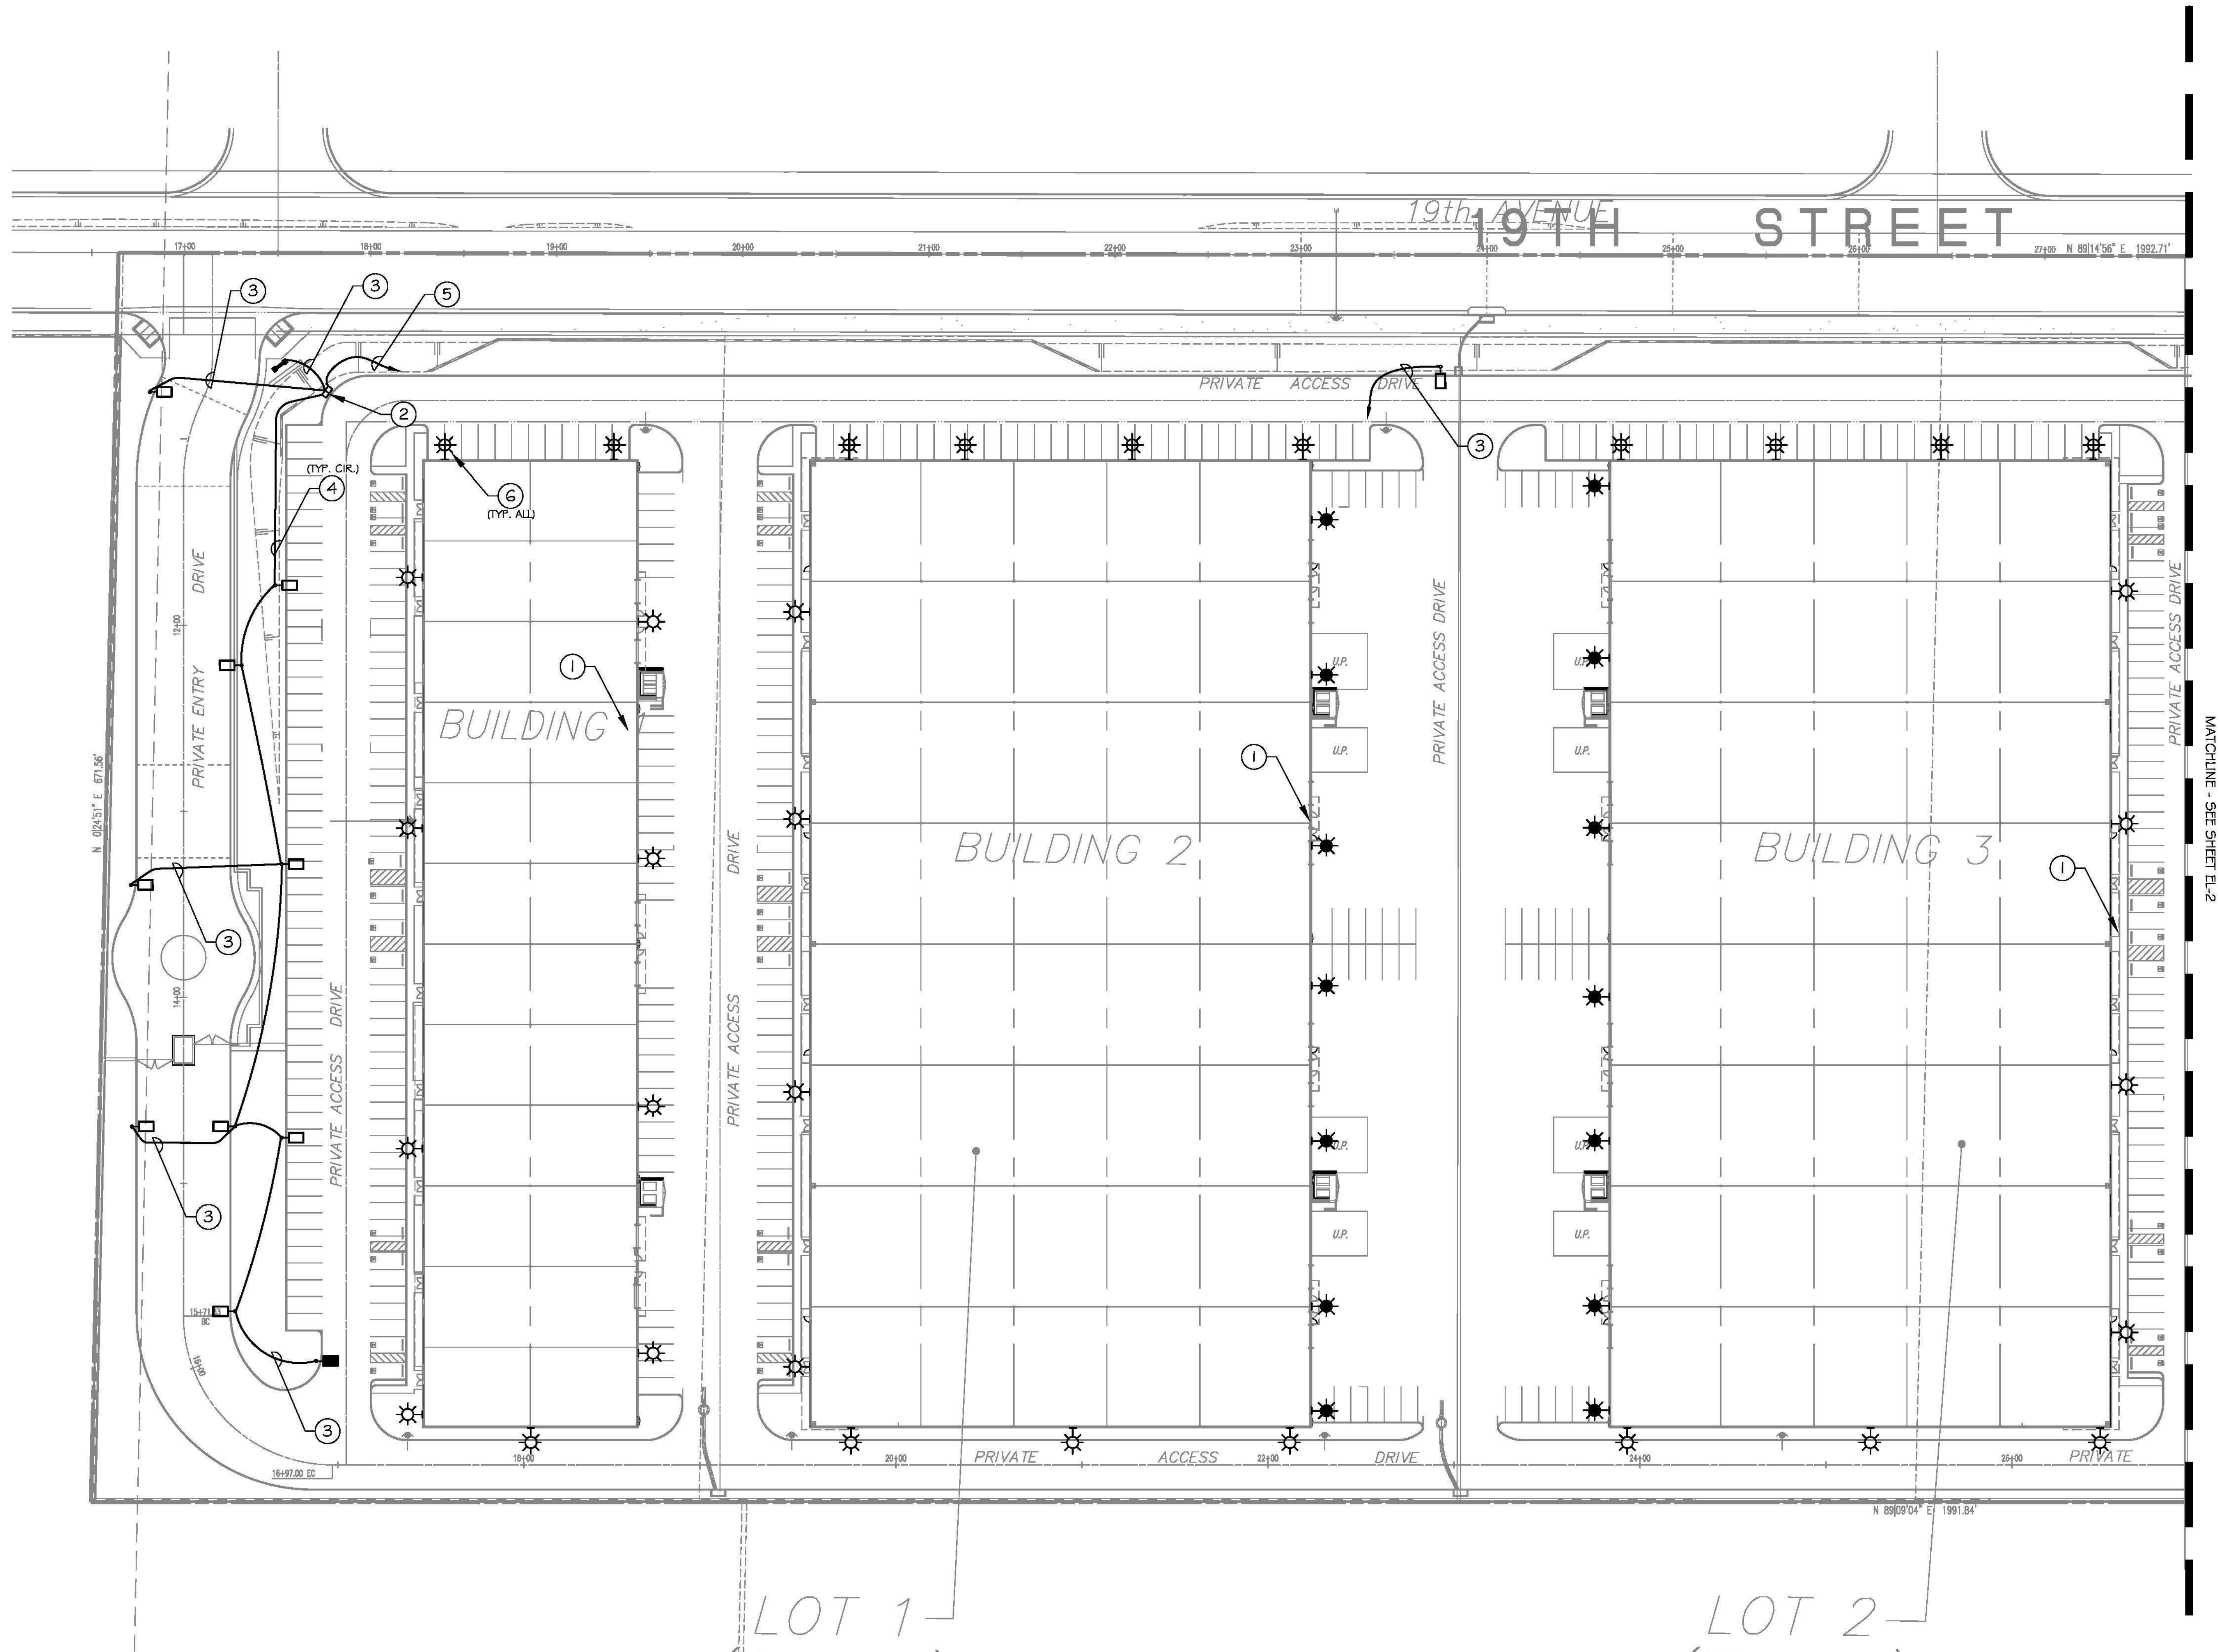

- PLAN NOTES
- 1 ELECTRICAL PANEL. VERIFY EXACT LOCATION.
 - 2 UNDERGROUND PULLBOX. SEE SPEC. XX AND DETAIL XEL-X.
 - 3 1" C-2#10, 1#10 GND. BURY 30" BELOW GRADE.
 - 4 1" C-4#10, 1#10 GND. BURY 30" BELOW GRADE.
 - 5 1 1/2" C-6#10, 1#10 GND. BURY 30" BELOW GRADE.
 - 6 WALL MOUNTED LIGHTS SHOWN FOR PURPOSE OF PHOTOMETRIC STUDY AND TITLE 24, "AUTOMOTIVE HARDSCAPE". SEE BUILDING ELECTRICAL PLANS FOR CIRCUITRY.

