



Visual Concepts Lighting, Inc.  
4655 Ruffner Street, - ste. #220  
San Diego, Ca  
92117  
tel: 858-278-4503  
email: kperez@visualconcepts-inc.com

Owner:



20201 SW Birch Street  
Suite 100  
Newport Beach, CA 92660  
tel: 949-252-1122  
email: rdorame@mastercraftresidential.com

Project:

GOLD FLORA  
FARMS

19th street & North Indian Cyn. Dr.  
Desert Hot springs, CA.

Consultants:

CIVIL  
STRUCTURAL  
MECHANICAL  
PLUMBING  
ELECTRICAL  
LANDSCAPE  
FIRE PROTECTION  
SOILS ENGINEER

MDS  
Visual Concepts Lighting  
RGA Landscape Arch.

Title:

LIGHTING PLAN 2

Project Number: MRC1611291


Drawn by: K.P.SR.

Date: 12/20/13

Revision:

Sheet:

EL-3

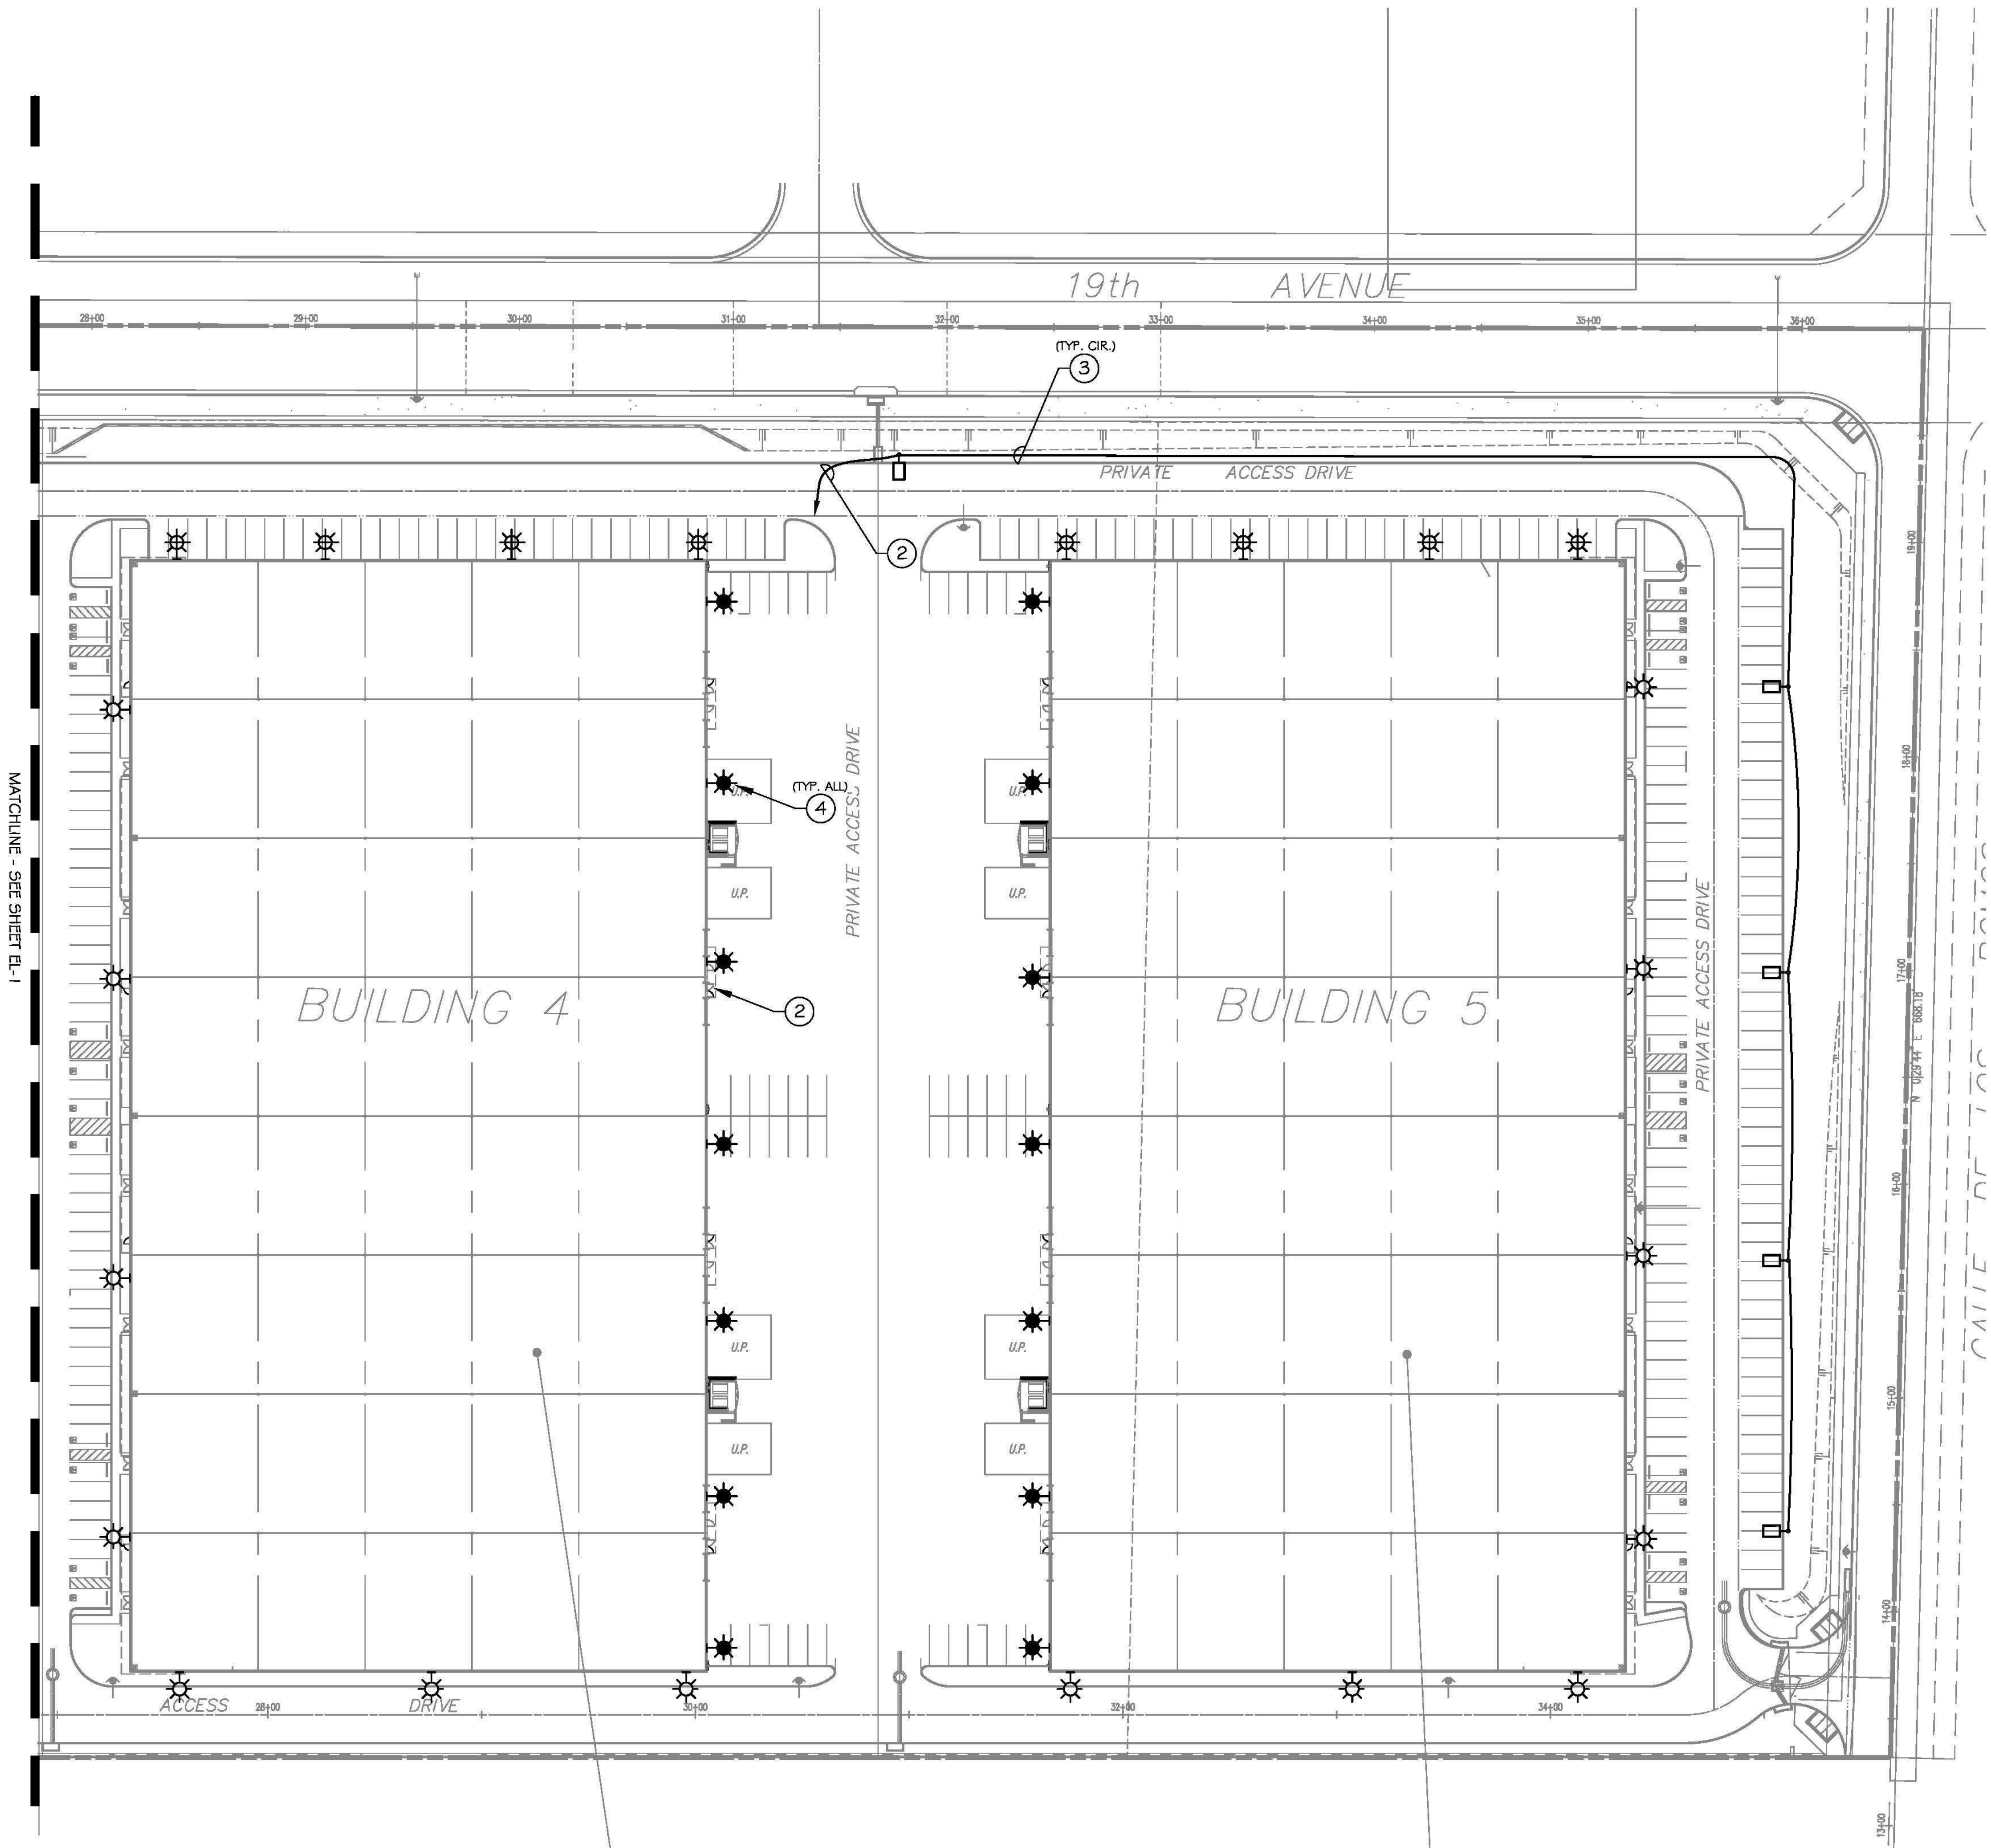

PLAN NOTES

- 1 ELECTRICAL PANEL. VERIFY EXACT LOCATION.
- 2 1 1/2" C-2#10, 1#10 GND. BURY 30" BELOW GRADE.
- 3 1" C-2#10, 1#10 GND. BURY 30" BELOW GRADE.
- 4 WALL MOUNTED LIGHTS SHOWN FOR PURPOSE OF PHOTOMETRIC STUDY AND TITLE-24, "AUTOMOTIVE HARDSCAPE". SEE BUILDING ELECTRICAL PLANS FOR CIRCUITRY.

