




ALLEN M. SANBORN
ARCHITECT

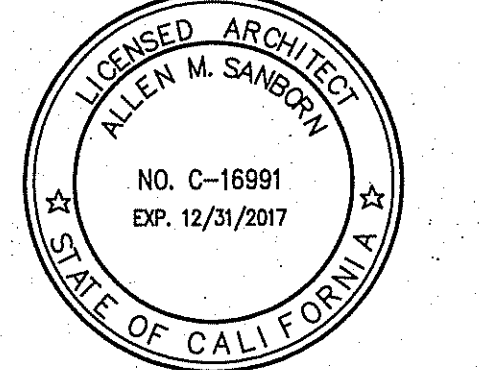

71-780 SAN JACINTO DR.
BLDG. "E-1"
RANCHO MIRAGE, CA. 92270
TEL (760) 423-0400
FAX (760) 423-0403

PROJECT TITLE:
**GREEN ACRES
ENTERPRISES**

DILLON ROAD,
Desert Hot Springs, CA

SHEET TITLE:
**LIGHTING
SITE PLAN**


REVISIONS		
1		
2		
3		

COPYRIGHT
THE USE OF THESE PLANS AND SPECIFICATIONS SHALL BE
RESTRICTED TO THE ORIGINAL SITE FOR WHICH THEY WERE
PREPARED AND PUBLICATION THEREOF IS EXPRESSLY LIMITED
TO SUCH USE. REPRODUCTION, PUBLICATION, OR RE-USE BY ANY
METHOD, IN WHOLE OR IN PART WITHOUT THE EXPRESS WRITTEN
CONSENT OF SANBORN A/E INC. IS PROHIBITED. TITLE TO THE
PLANS AND SPECIFICATIONS SHALL REMAIN IN SANBORN A/E INC.
WITHOUT PREJUDICE. VISUAL CONTACT WITH THESE PLANS AND
SPECIFICATIONS SHALL CONSTITUTE FRAUDULENT EVIDENCE OF THE
ACCEPTANCE OF THESE RESTRICTIONS.


W.O.	16-137	SCALE 1"=20'
FILE NAME	AIO SITE	
SAVE DATE	3/30/2017	
DRAWN	Allen Sanborn	
SHEET NO.		

E1.0

DILLON ROAD

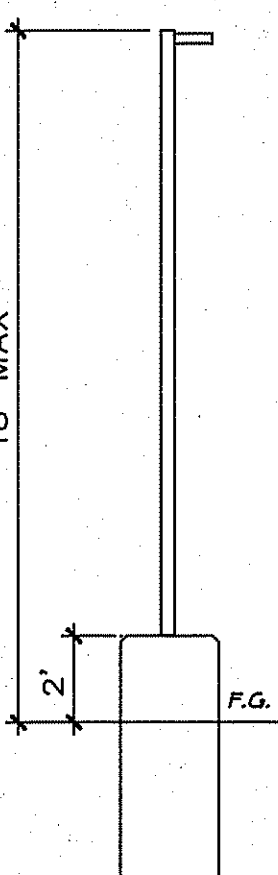

TYPICAL LIGHT POLE
N.T.S.

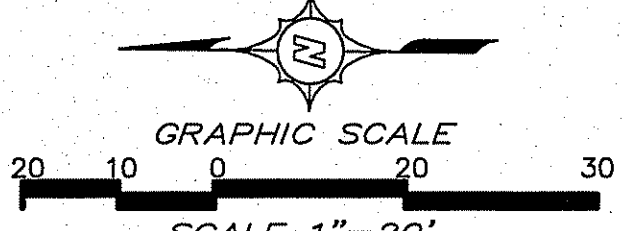

WPLED2T50/PC

Project: _____ **Type:** _____

Prepared By: _____ **Date:** _____

Order Info:

Type:	WPLED2T50/PC	Wattage:	50W
Order:	50W	Color Temp:	5000K
2500:	50W	Color Accuracy:	90 CRI
2500:	50W	LED Lifetime:	50,000Hrs
2500:	50W	Beam Angle:	60°
2500:	50W	Input Voltage:	120V
2500:	50W	Efficiency:	90%

Technical Specifications:

Electrical:

- Power: 50W
- Color: 5000K
- Color Accuracy: 90 CRI
- Color Temperature: 5000K
- Color Rendering: 90 CRI
- Color Temperature: 5000K
- Color Rendering: 90 CRI
- Color Temperature: 5000K
- Color Rendering: 90 CRI

Physical:

- Weight: 1.5 lbs
- Dimensions: 10" x 10" x 10"
- Material: Aluminum
- Finish: Powder Coat
- Mounting: 1/2" x 1/2" x 1/2"
- Adjustable: Yes
- Weather Resistant: Yes
- UL Listed: Yes
- CE Marked: Yes
- RoHS Compliant: Yes
- Warranty: 5 Years

ALED2T260/D10/LC

Project: _____ **Type:** _____

Prepared By: _____ **Date:** _____

Order Info:

Type:	ALED2T260/D10/LC	Wattage:	260W
Order:	260W	Color Temp:	5000K
2500:	260W	Color Accuracy:	90 CRI
2500:	260W	LED Lifetime:	50,000Hrs
2500:	260W	Beam Angle:	60°
2500:	260W	Input Voltage:	120V
2500:	260W	Efficiency:	90%

Technical Specifications:

Electrical:

- Power: 260W
- Color: 5000K
- Color Accuracy: 90 CRI
- Color Temperature: 5000K
- Color Rendering: 90 CRI
- Color Temperature: 5000K
- Color Rendering: 90 CRI
- Color Temperature: 5000K
- Color Rendering: 90 CRI

Physical:

- Weight: 1.5 lbs
- Dimensions: 10" x 10" x 10"
- Material: Aluminum
- Finish: Powder Coat
- Mounting: 1/2" x 1/2" x 1/2"
- Adjustable: Yes
- Weather Resistant: Yes
- UL Listed: Yes
- CE Marked: Yes
- RoHS Compliant: Yes
- Warranty: 5 Years

POLE LIGHT FIXTURE
N.T.S.

WALL LIGHT FIXTURE
N.T.S.

