
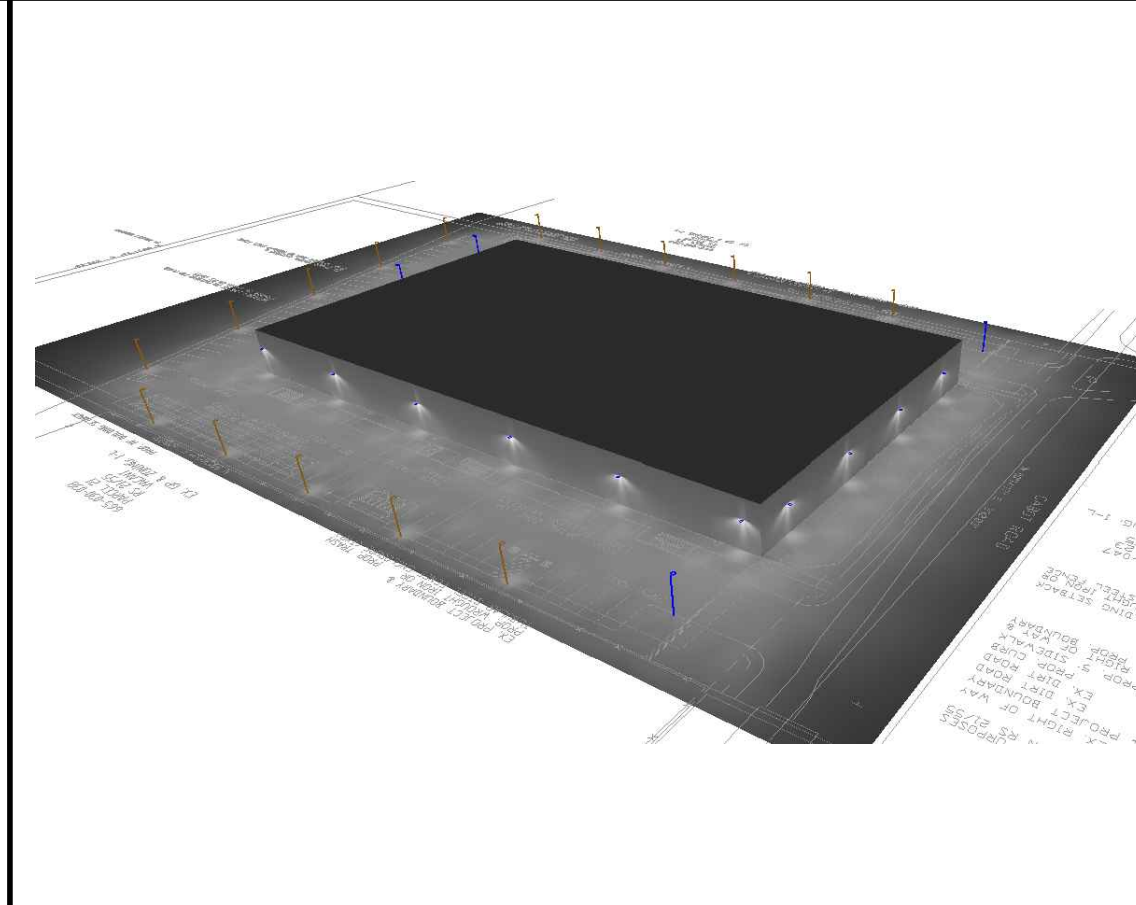


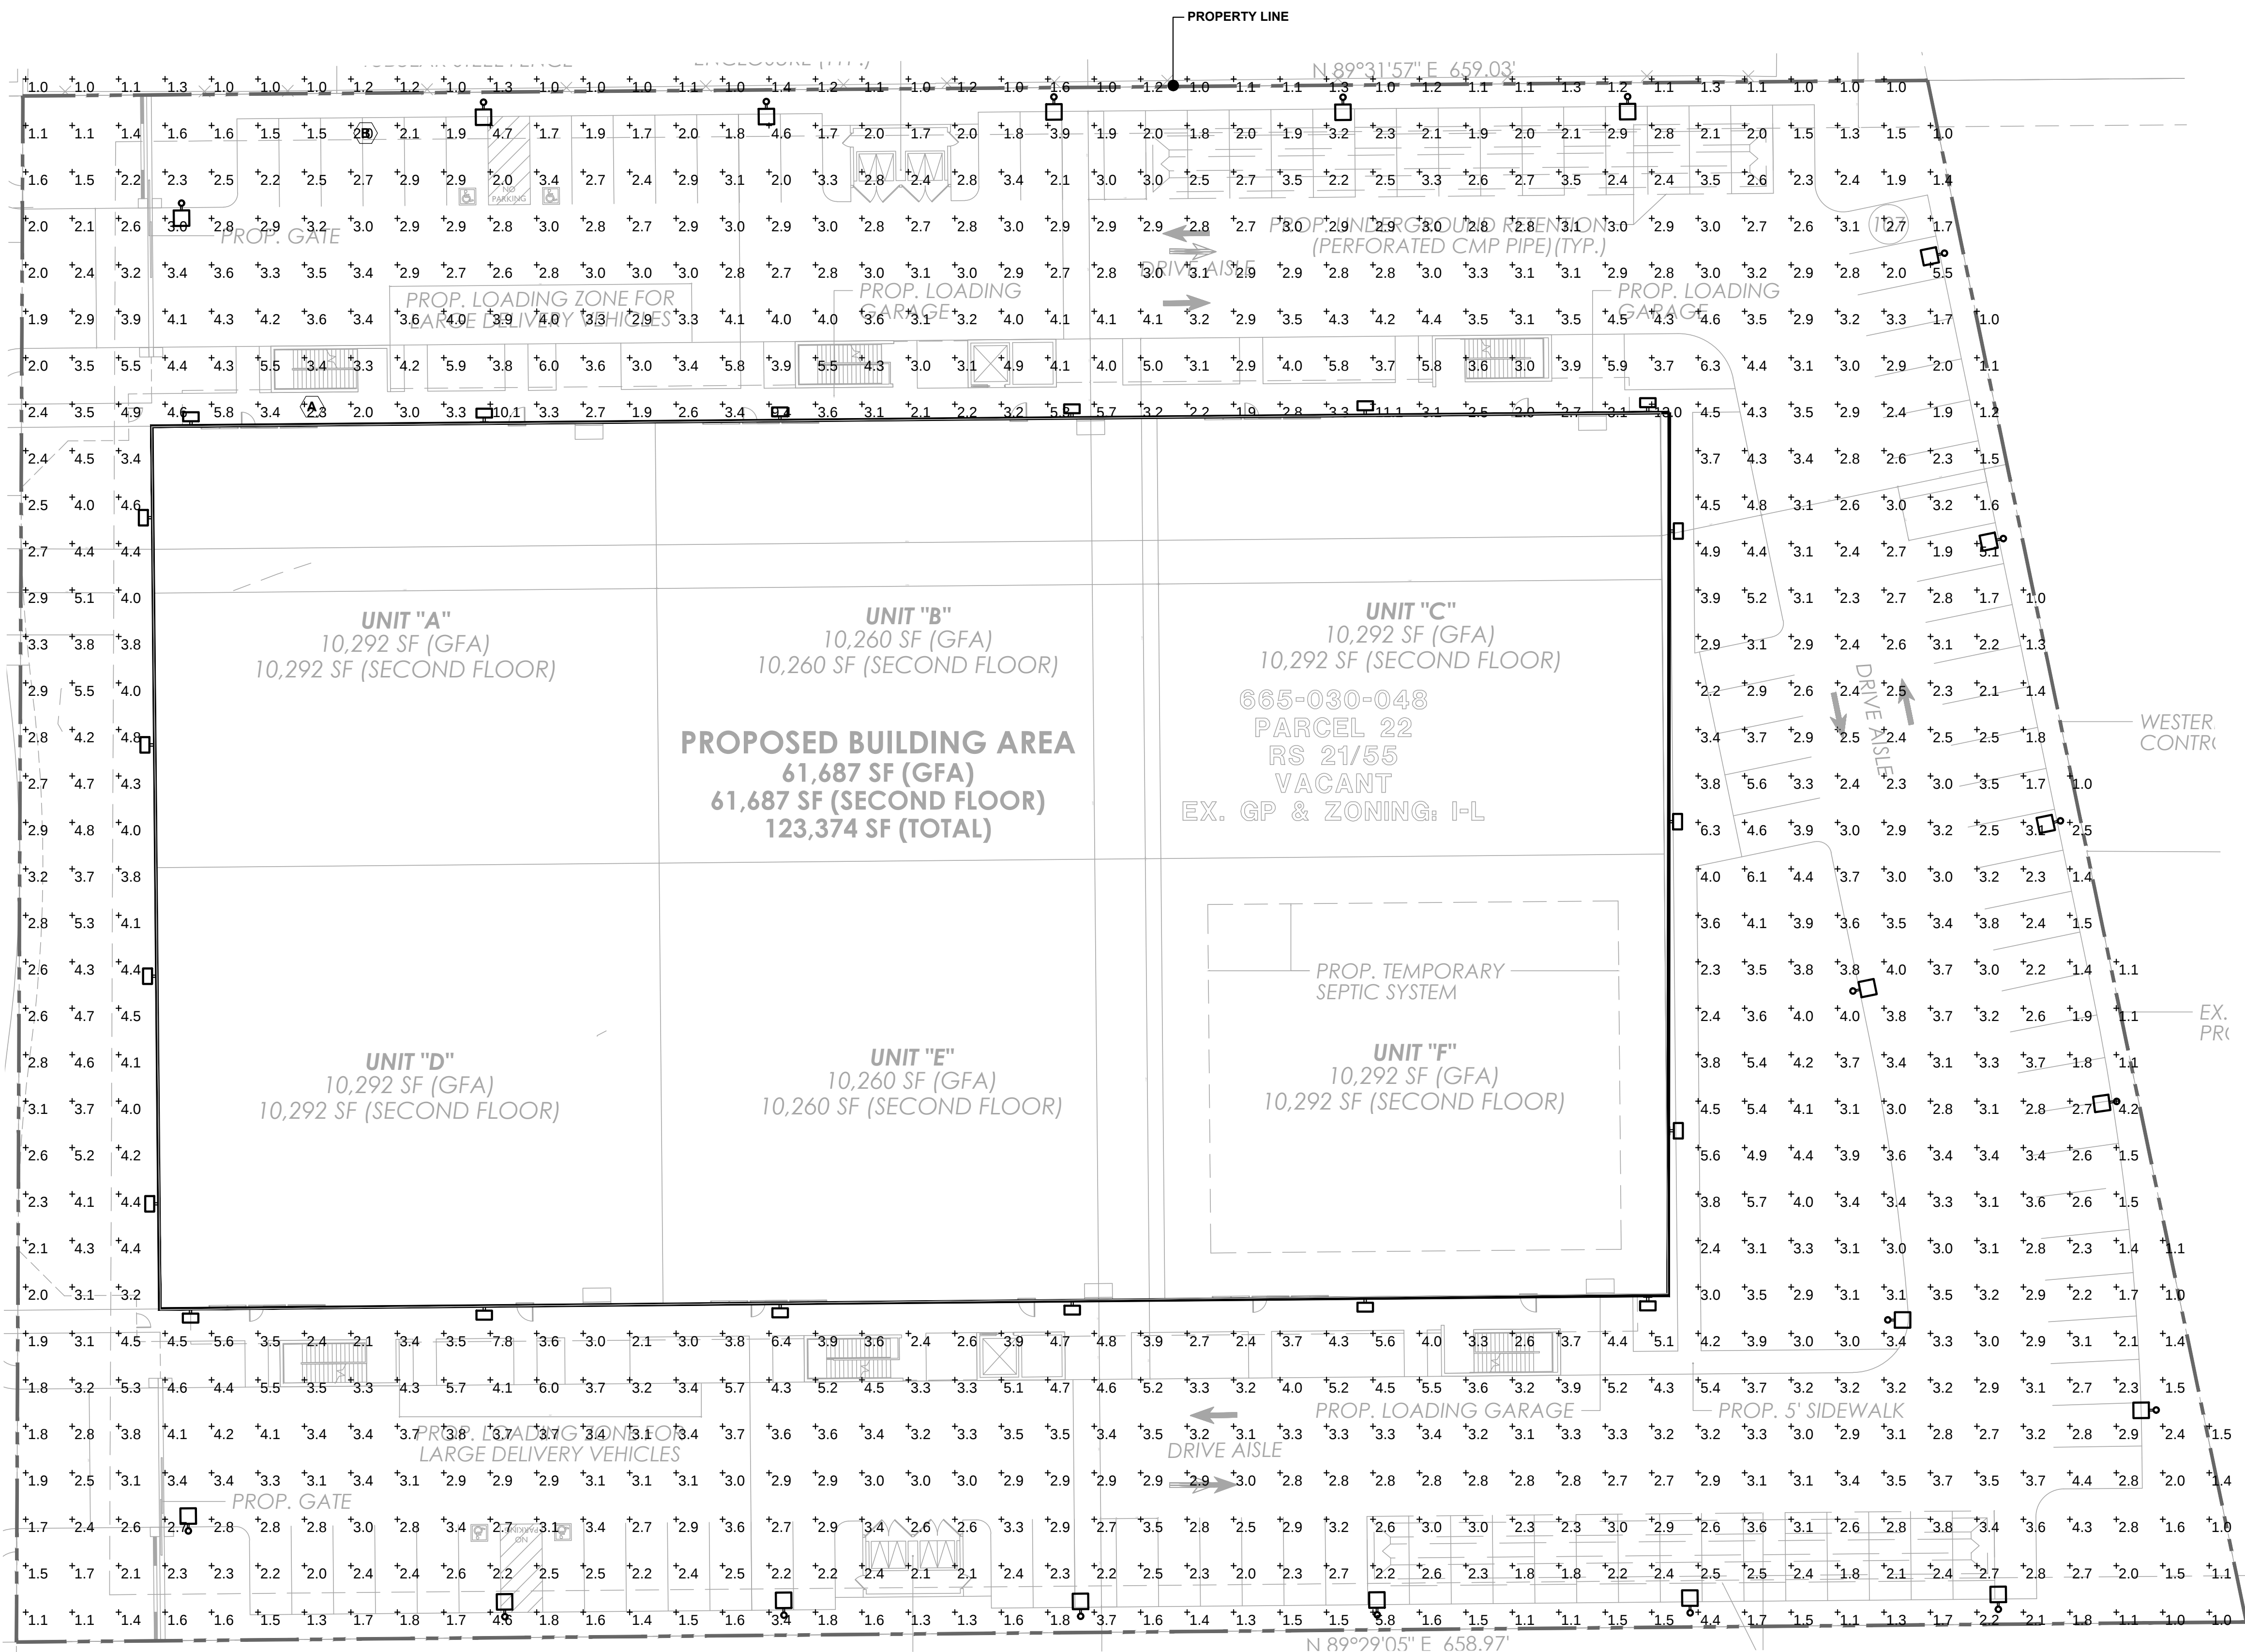

**Professional Engineers
& Lighting Consultants**
34300 Gateway Drive, Suite 120
Palm Desert, CA 92211
o: 760-340-9005 f: 760-340-9100

PROJECT:

DHS Development Cultivation Facility

DESERT HOT SPRINGS, CA

[illegible]

LIGHT FIXTURE "A"

[illegible]

LIGHT FIXTURE "B"

DATE: 03-30-2017

DRAWN BY: GL

CHECKED BY: FR

PROJECT NO.: 17022

PHOTOMETRIC
SITE PLAN

SHEET NO.:

E1.0

SCALE:	2
11.00% 01	

CUT SHEETS

SCALE:	1
N/A	