


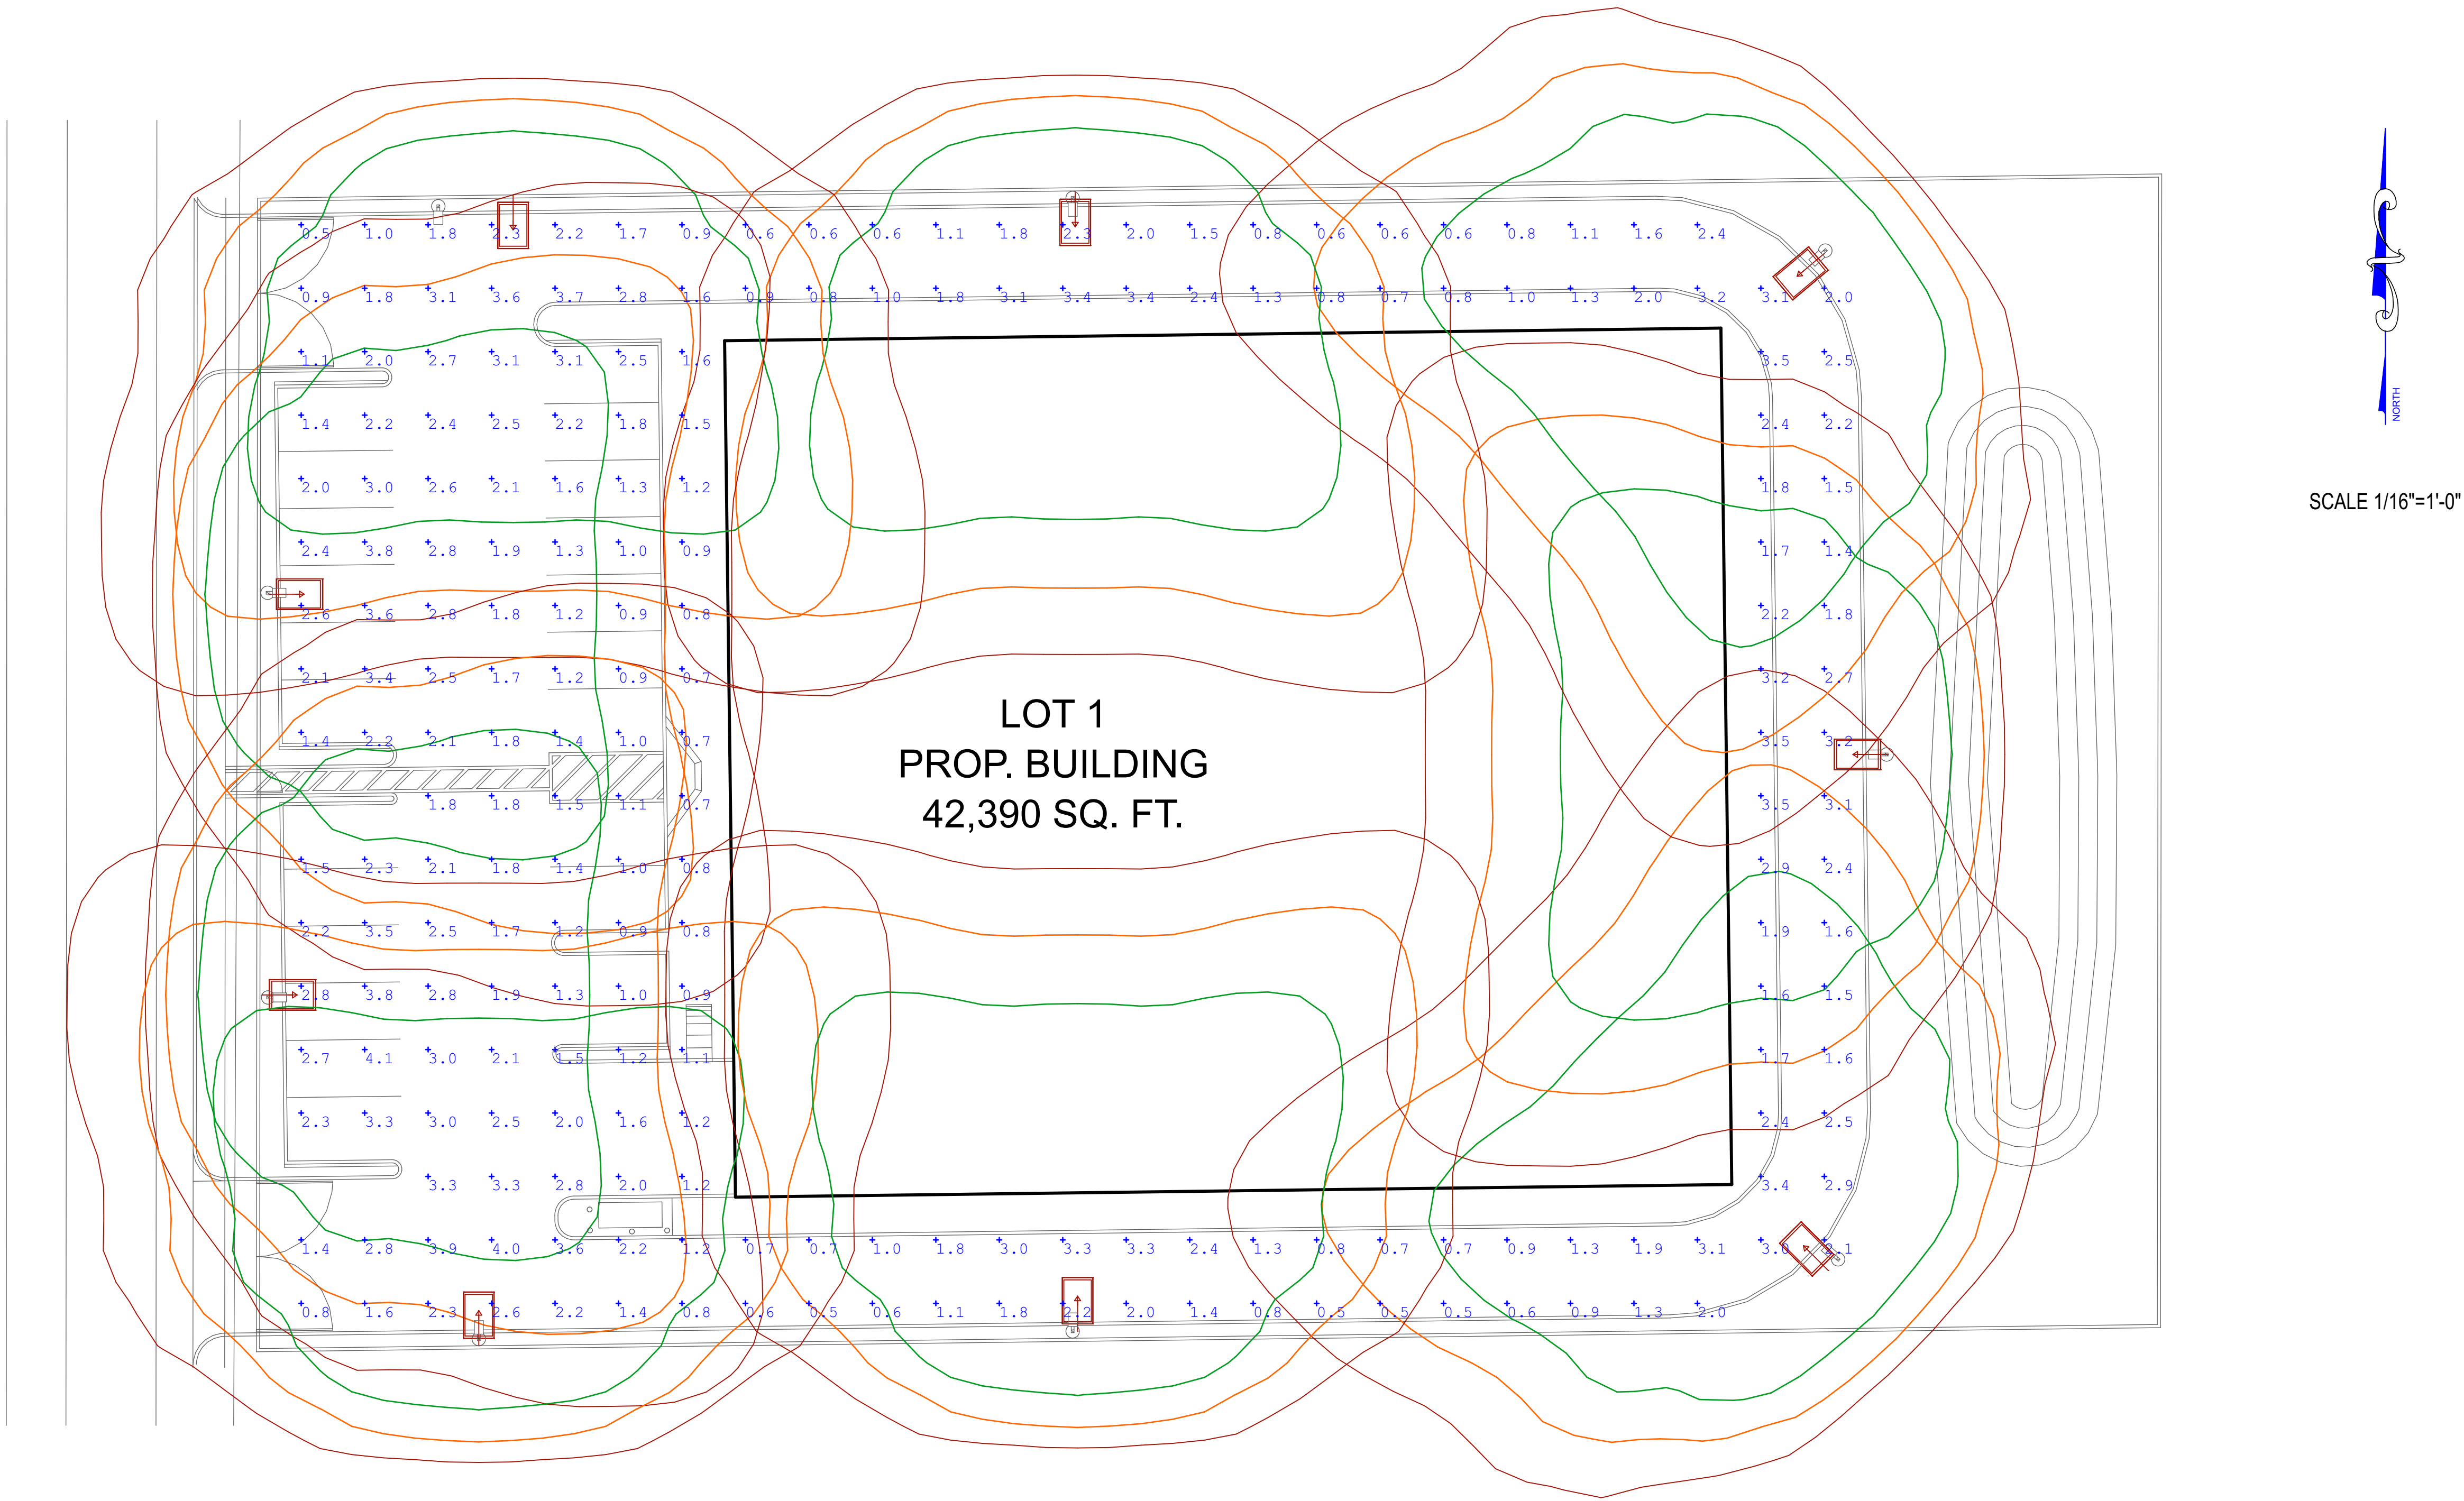

Luminaire Schedule						
Symbol	Qty	Label	Arrangement	LLF	Description	Arr. Watts
	9	ASL-16L-3K-210-4-EHS	SINGLE	1.000	ASL-16L-3K-210-4-EHS	115

Luminaire Location Summary						
LumNo	Label	X	Y	Z	Orient	Tilt
1	ASL-16L-3K-210-4-EHS	1144.987	684.22	25	0	0
2	ASL-16L-3K-210-4-EHS	1143.872	621.061	25	0	0
3	ASL-16L-3K-210-4-EHS	1178.041	565.765	25	90	0
4	ASL-16L-3K-210-4-EHS	1272.393	568.046	25	90	0
7	ASL-16L-3K-210-4-EHS	1390.682	577.615	25	135	0
8	ASL-16L-3K-210-4-EHS	1400.096	658.958	25	180	0
9	ASL-16L-3K-210-4-EHS	1272.017	747.647	25	270	0
10	ASL-16L-3K-210-4-EHS	1183.449	747.164	25	270	0
11	ASL-16L-3K-210-4-EHS	1390.005	737.882	25	220	0

Calculation Summary								
Label	CalcType	Units	Avg	Max	Min	Avg/Min	Max/Min	
Parking	Illuminance	Fc	1.88	4.1	0.5	3.76	8.20	

Sipovac

CONSTRUCTION INNOVATION

Skillfully Navigating the Building Process

72-651 THEODORA LN. PALM DESERT CA. 92260

LIC. # 581636 OFFICE: 760-567-2347 FAX: 760-779-9525

CONSULTANTS

ENGINEERING:

Amir Engineering & Surveying inc.
160 Luring Dr. suite A
Palm Springs, CA 92262
(760) 318-7424

MECHANICAL:

N/A

PHOTOMETRIC:

Design & Drawings by Sipovac Construction Inc
72-651 Theodora Ln. Palm Desert Ca. 92260
(760) 567-2347
Lic # 581636

GENERAL CONTRACTOR

Bob Sipovac
72-651 Theodora Lane
Palm Desert, CA 92260
760-567-2347
Lic # 581636

OWNER

Kami Amirianfar

737 South Crocker street Los Angeles, CA 90021

PARCEL #4 RS 32/95 LITTLE MORONGO ROAD DESERT HOT SPRING , CA. SEC. 1, T. 3 S., R. 4 E., S.B.B.M.

MARK	DATE	DESCRIPTION
SCALE:		
PROJECT NO: 062617		
MODEL FILE: 06.26.2017.pln		
DRAWN BY: Eugene Drozdov		
CHK'D BY: Bob Sipovac		
COPYRIGHT Sipovac Construction Inc.		
SHEET TITLE Photometric Plan		
L-101 SHEET 1 OF 2		