
 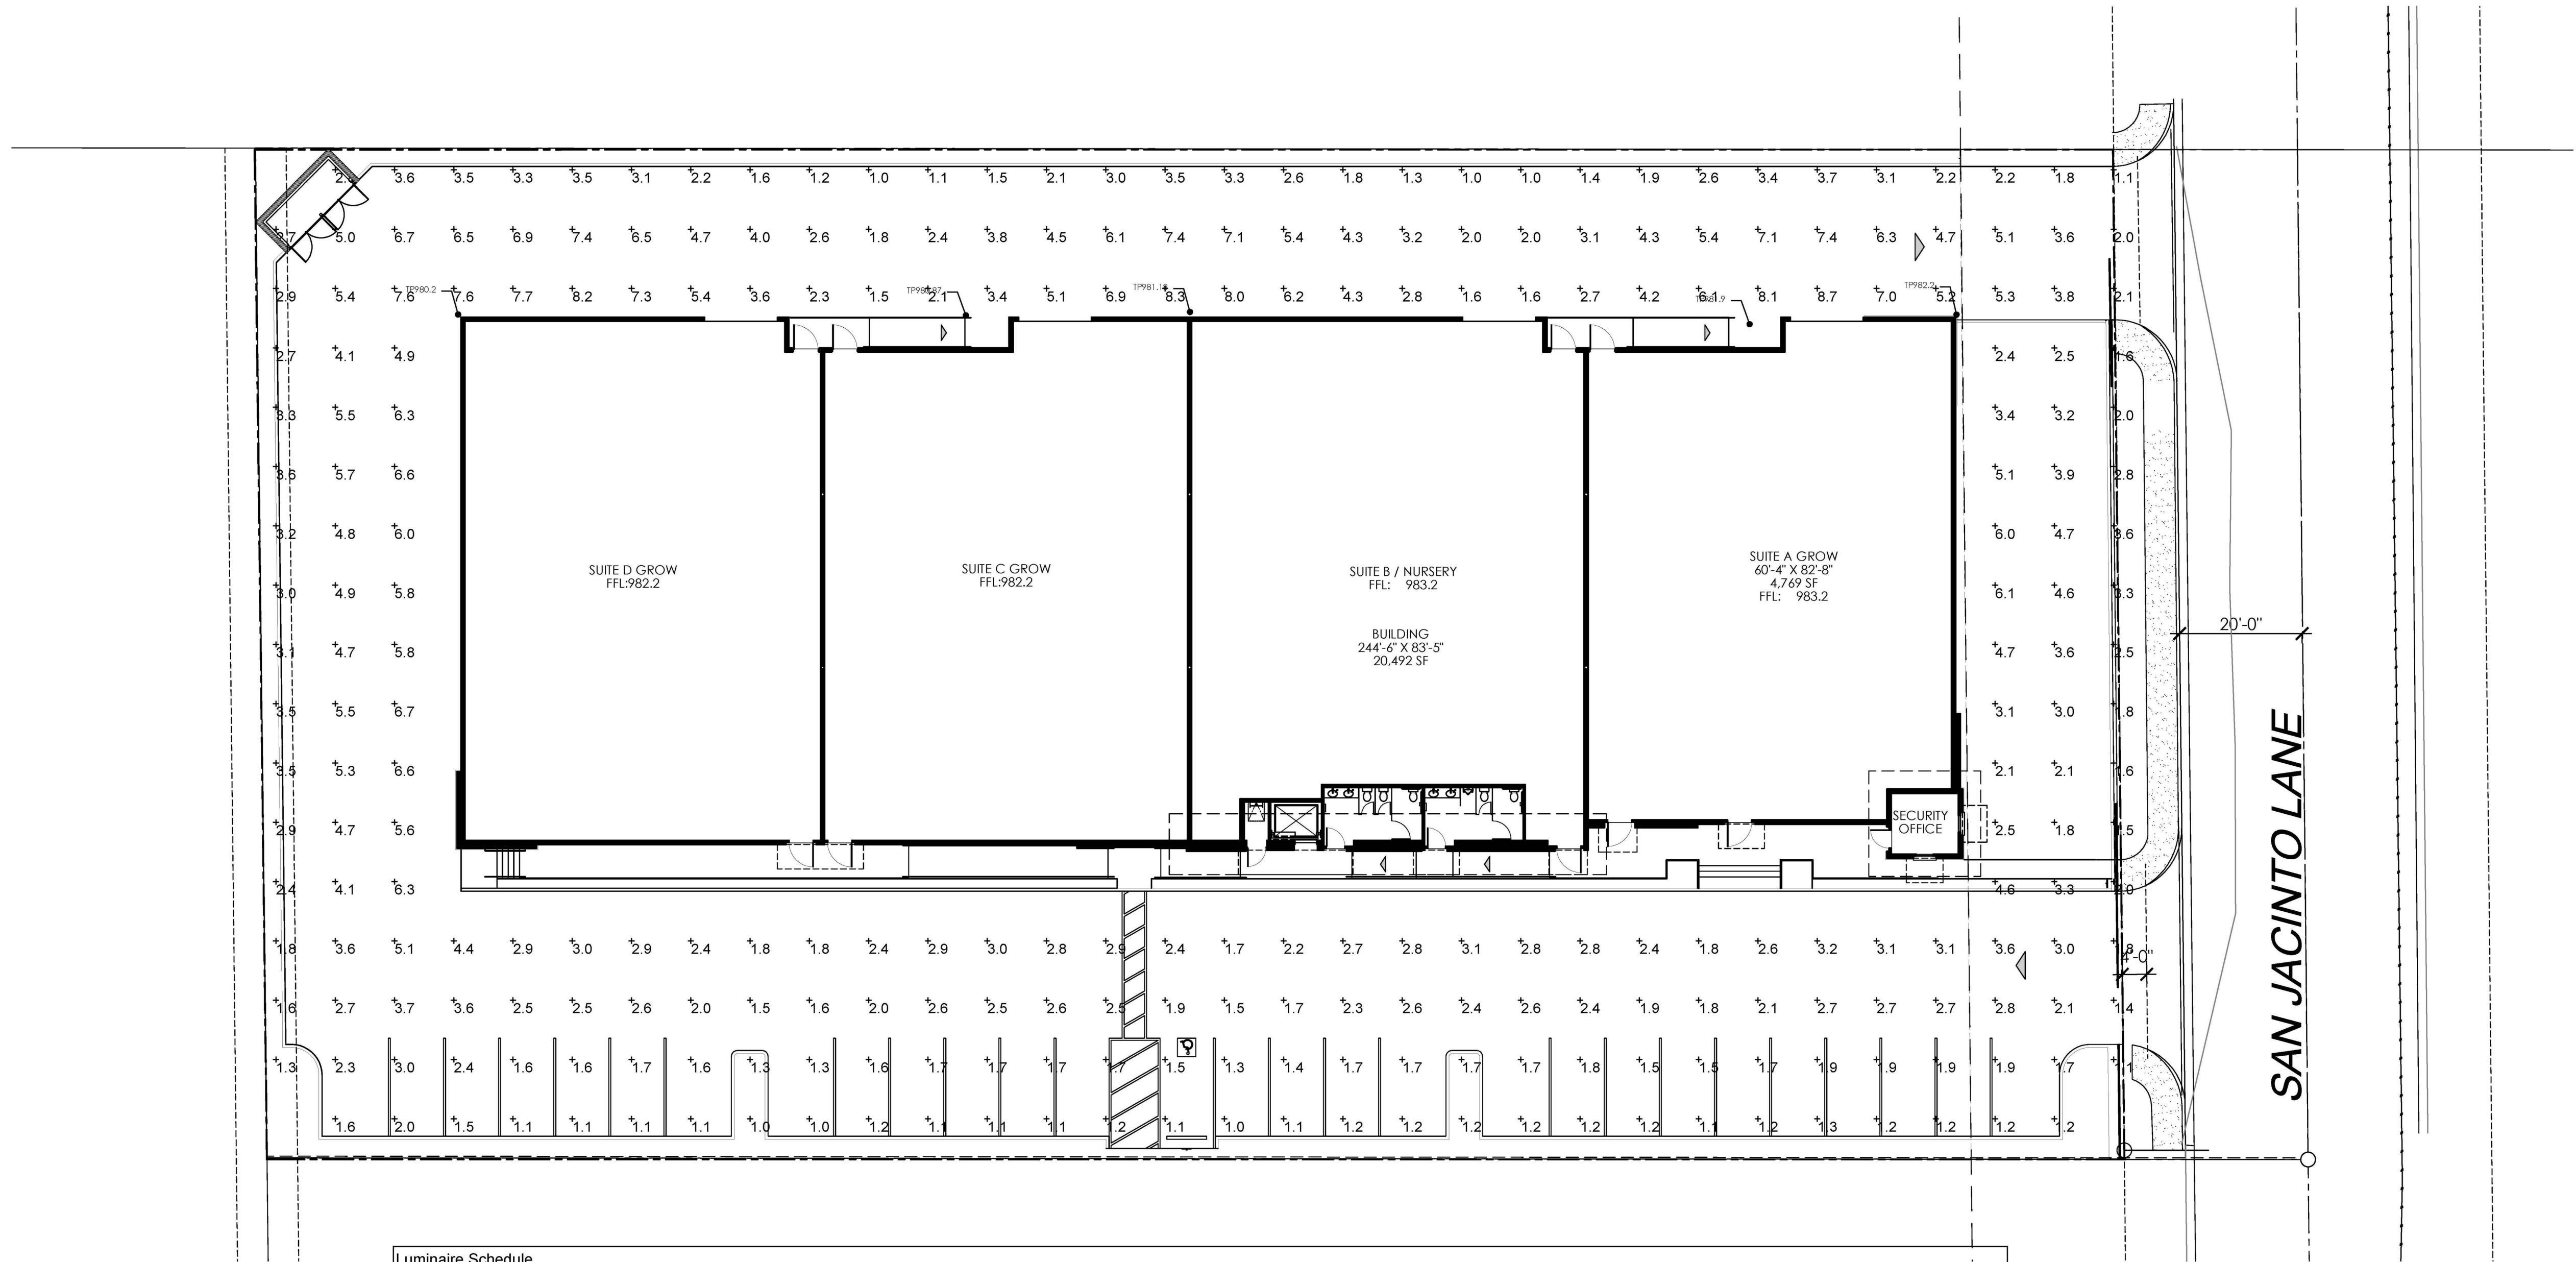
 
 




Luminaire Schedule											
Symbol	Label	Quantity	Manufacturer	Catalog Number	Description	Lamp	Number Lamps	Filename	Lumens Per Lamp	Light Loss Factor	Wattage
	A	3	U.S. ARCHITECTURAL LIGHTING	RZR-WM3-II-60PLED-1050mA-NW WALL MT AT 17 FT AFG	CAST BLACK PAINTED FINNED METAL HOUSING, CAST BLACK PAINTED METAL DRIVER COVER, 3 CIRCUIT BOARDS EACH WITH 20 LEDs, 1 CLEAR PLASTIC OPTIC BELOW EACH LED, 1 FORMED SEMI-SPECULAR METAL OPTIC MOUNTING PLATE BELOW EACH CIRCUIT BOARD.	SIXTY WHITE LIGHT EMITTING DIODES (LEDs), VERTICAL BASE-UP POSITION.	60	RZR-WM3-2-60PLED-NW-1050.ies	290.6909	0.9	200.2
	B	3	U.S. ARCHITECTURAL LIGHTING	RZR-WM3-III-W-60PLED-NW-1050 WALL MNT AT 17 FT AFG	RAZAR WM3 PLED		60	RZR-WM3-3W-60PLED-NW-1050.ies	274.032	0.9	200
	C	4	U.S. ARCHITECTURAL LIGHTING	RZR-WM3-IV-FT-60PLED-700mA-NW WALL MT AT 17 FT AFG	CAST BLACK PAINTED FINNED METAL HOUSING, CAST BLACK PAINTED METAL DRIVER COVER, 3 CIRCUIT BOARDS EACH WITH 20 LEDs, 1 CLEAR PLASTIC OPTIC BELOW EACH LED, 1 FORMED SEMI-SPECULAR METAL OPTIC MOUNTING PLATE BELOW EACH CIRCUIT BOARD.	SIXTY WHITE LIGHT EMITTING DIODES (LEDs), VERTICAL BASE-UP POSITION.	60	RZR-WM3-4FT-60PLED-NW-700.ies	207.7859	0.9	130.1

Statistics						
Description	Symbol	Avg	Max	Min	Max/Min	Avg/Min
Calc Zone #1	+	3.1 fc	8.7 fc	1.0 fc	8.7:1	3.1:1

SAN JACINTO LN, LLC

18960 VENTURA BOULEVARD, SUITE 25
LOS ANGELES, CA 91356
818/580-1552

SAN JACINTO GROW

APN# 665-030-036
DESERT HOT SPRINGS, CA

PHOTOMETRIC LIGHTING PLAN



SCALE: 1/16"=1'-0"



ARCHITECTURE PLANNING INTERIORS
WILLIAM MASON ARCHITECT, INC.

3276 DAKOTA AVENUE
COSTA MESA, CALIFORNIA 92626
714.427.0688 EMAIL: Bill@WilliamMasonArchitect.com
17.032.00 10.30.17