

CONSULTANTS

ENGINEERING:

Amir Engineering & Surveying inc.
160 Luring Dr. suite A
Palm Springs, CA 92262
(760) 318-7424

MECHANICAL:

N/A

PHOTOMETRIC:

Design & Drawings by Sipovac Construction Inc
72-651 Theodora Ln. Palm Desert Ca. 92260
(760) 567-2347
Lic # 581636

GENERAL CONTRACTOR

Bob Sipovac
72-651 Theodora Lane
Palm Desert, CA 92260
760-567-2347
Lic # 581636


OWNER

65265 SAN JACINTH LANE, DESERT HOT
SPRINGS, CA. SEC.1, T. 3 S., R. 4E.,
S.B.B.M.

MARK	DATE	DESCRIPTION
------	------	-------------

SCALE:		
PROJECT NO:	062617	
MODEL FILE:	06.26.2017.pln	
DRAWN BY:	Bob Sipovac	
CHK'D BY:	Eugene Drozdov	
COPYRIGHT	Sipovac Construction Inc.	

SHEET TITLE
Photometric Plan

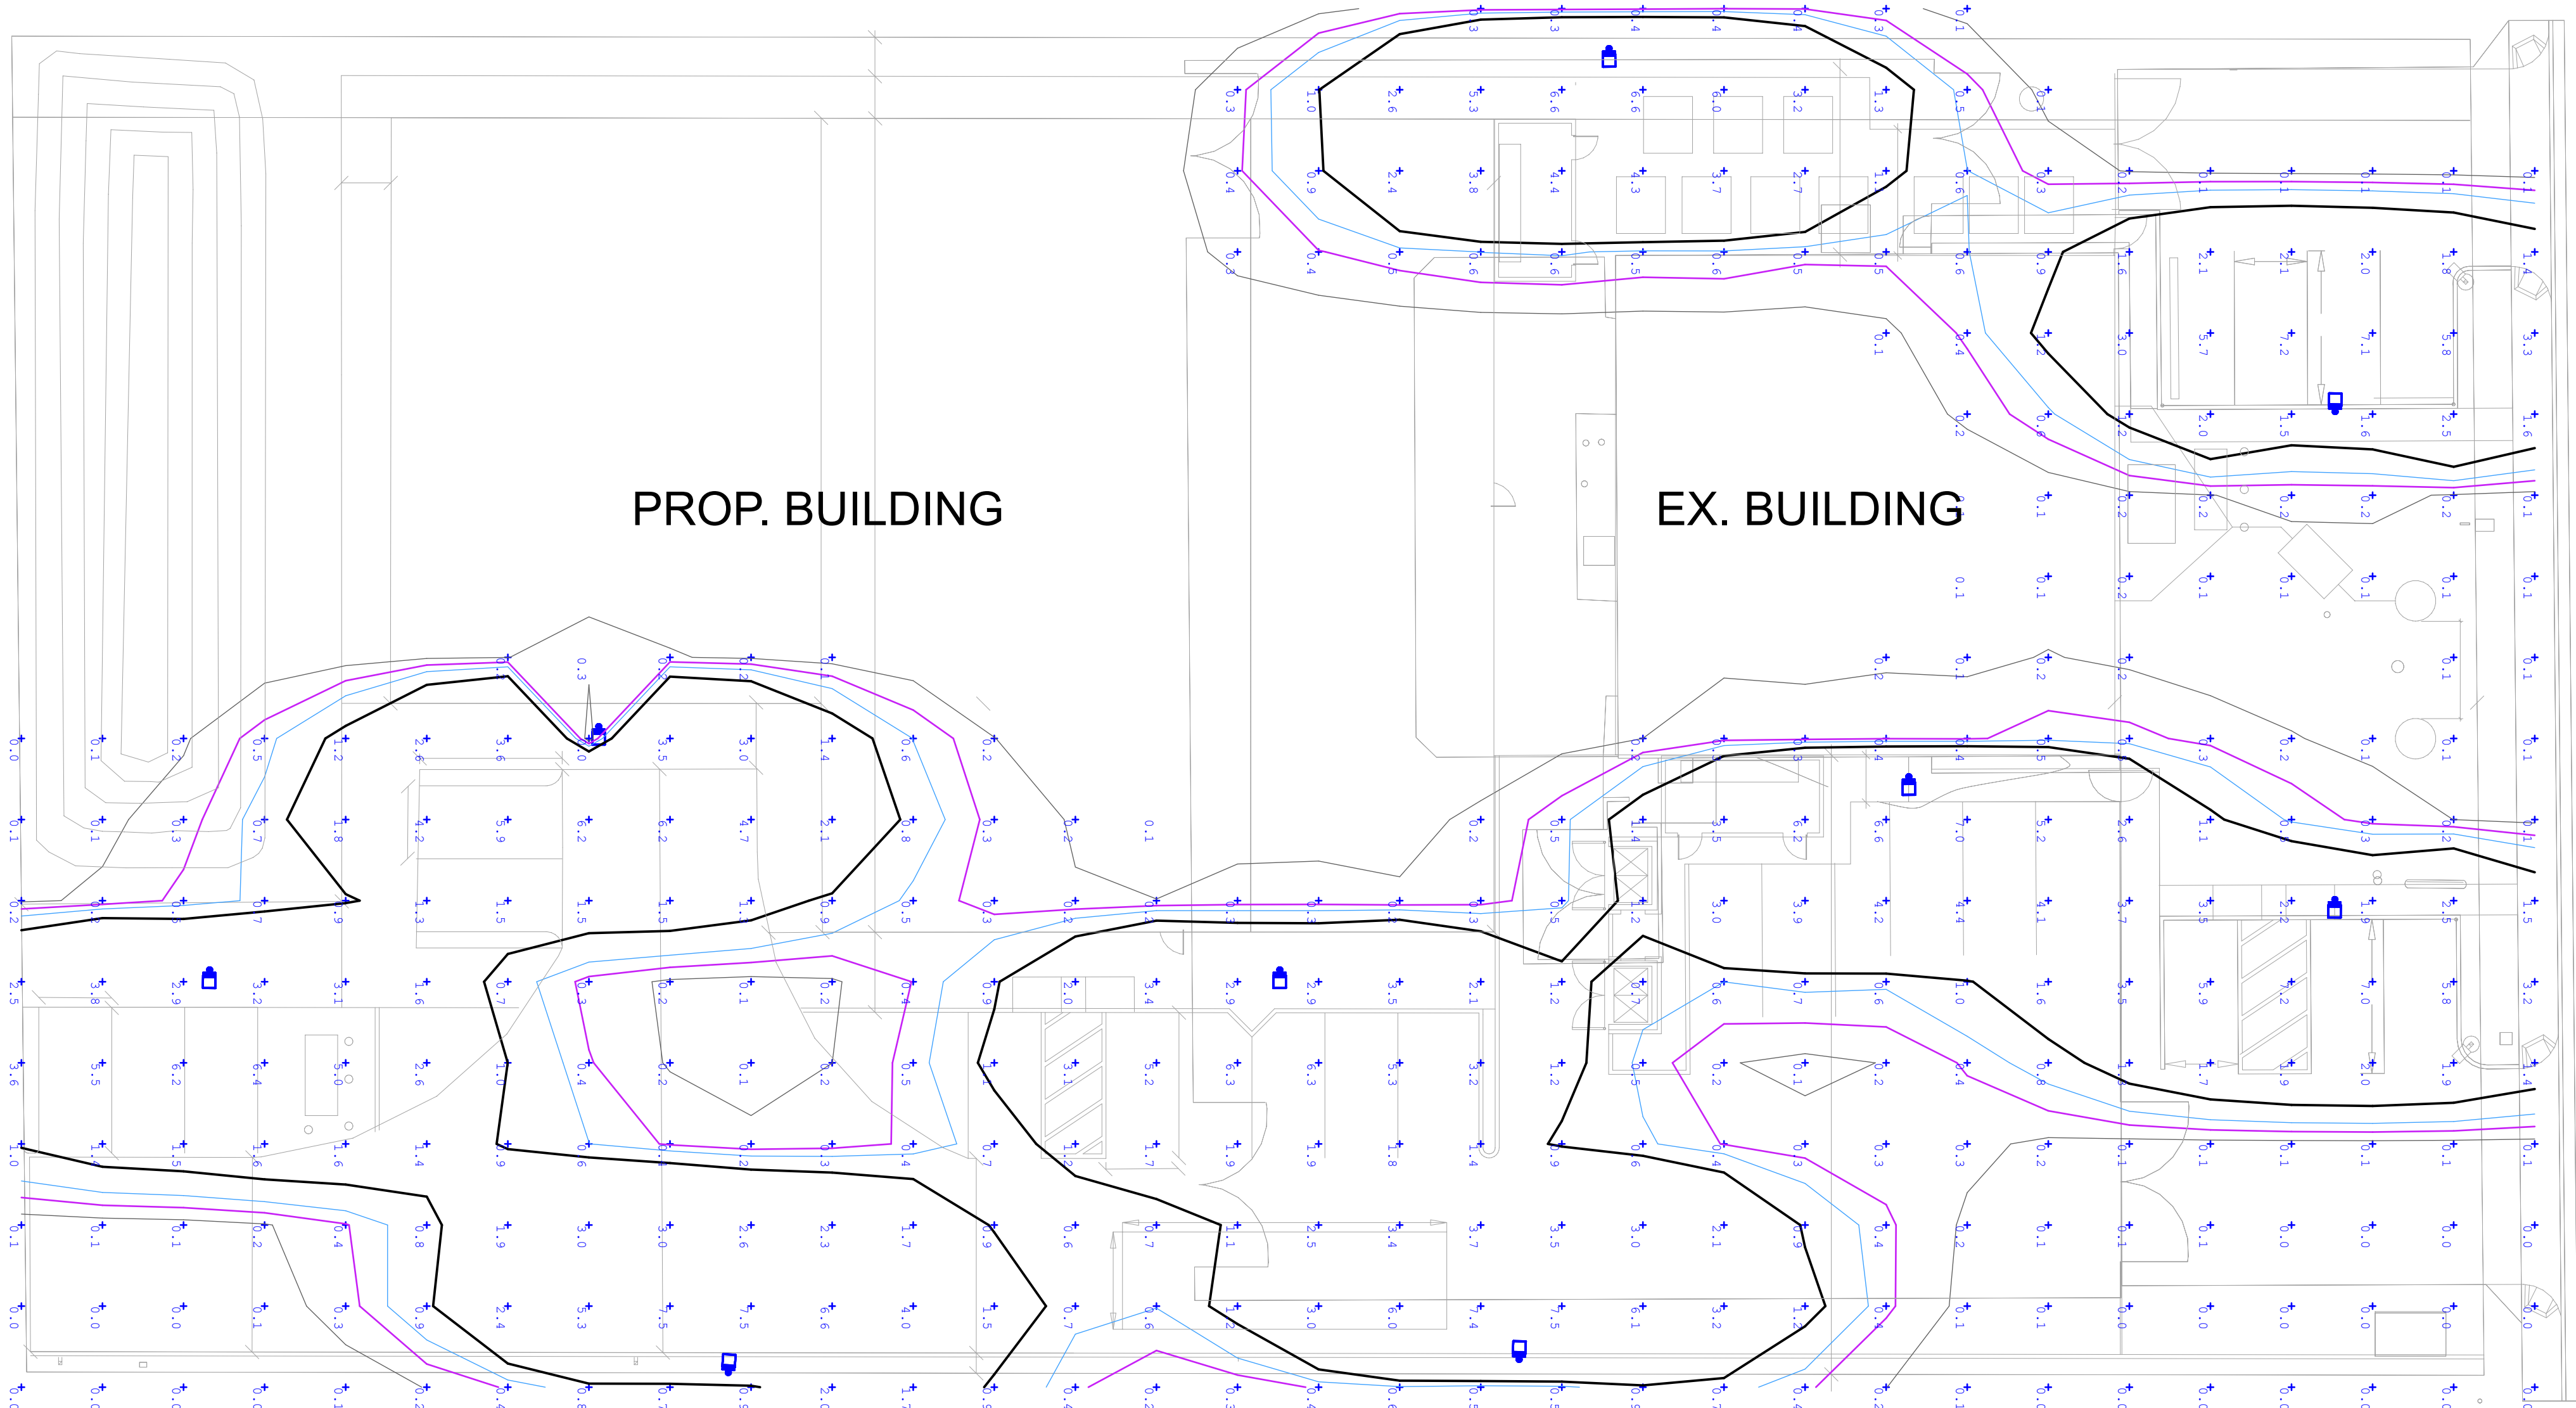

Luminaire Schedule						
Symbol	Qty	Label	Arrangement	Total Lamp Lumens	LLF	Description
	9	CLI-30L-3K-1A	SINGLE	N.A.	1.000	CLI-30L-3K-1A

Expanded Luminaire Location Summary										
LumNo	Label	X	Y	Z	Orient	Tilt	X-Aimpt	Y-Aimpt	Z-Aimpt	TCF
7	CLI-30L-3K-1A	9389.771	8264.993	20	359.448	0	9389.771	8264.993	0	1
8	CLI-30L-3K-1A	9451.445	8263.319	20	180.727	0	9451.445	8263.319	0	1
9	CLI-30L-3K-1A	9390.817	8197.646	20	6.198	0	9390.817	8197.646	0	1
11	CLI-30L-3K-1A	9452.701	8203.851	20	179.202	0	9452.701	8203.851	0	1
12	CLI-30L-3K-1A	9417.802	8321.307	20	271.215	0	9417.802	8321.307	0	1
13	CLI-30L-3K-1A	9516.348	8322.525	20	270.726	0	9516.348	8322.525	0	1
14	CLI-30L-3K-1A	9421.967	8139.77	20	92.49	0	9421.967	8139.77	0	1
15	CLI-30L-3K-1A	9517.99	8140.771	20	90.727	0	9517.99	8140.771	0	1
16	CLI-30L-3K-1A	9651.432	8143.521	20	137.49	0	9651.432	8143.521	0	1
18	CLI-30L-3K-1A	9650.24	8236.271	20	180.958	0	9650.24	8236.271	0	1
19	CLI-30L-3K-1A	9613	8323.229	20	270	0	9613	8323.229	0	1
20	CLI-30L-3K-1A	9616	8142.771	20	90	0	9616	8142.771	0	1
21	CLI-30L-3K-1A	10870.97	9292.25	20	179.13	0	10870.97	9292.25	0	1
22	CLI-30L-3K-1A	10930.09	9294.121	20	359.614	0	10930.09	9294.121	0	1
23	CLI-30L-3K-1A	10915.19	9252.827	20	1.012	0	10915.19	9252.827	0	1
24	CLI-30L-3K-1A	10940.77	9167	20	0	0	10940.77	9167	0	1
25	CLI-30L-3K-1A	10824.88	9204.046	20	0.285	0	10824.88	9204.046	0	1
26	CLI-30L-3K-1A	10986.3	9159.07	20	180	0	10986.3	9159.07	0	1
27	CLI-30L-3K-1A	10986.09	9085.306	20	180.671	0	10986.09	9085.306	0	1
28	CLI-30L-3K-1A	10908.77	9080	20	0	0	10908.77	9080	0	1
29	CLI-30L-3K-1A	10940.82	9026.065	20	359.671	0	10940.82	9026.065	0	1

Calculation Summary						
Label	CalcType	Units	Avg	Max	Min	Avg/Min
CalcPts_1	Illuminance	Fc	1.26	9.7	0.0	N.A.
CalcPts_2	Illuminance	Fc	0.93	7.4	0.0	N.A.