


100' Greenhouse
SCALE: 1" = 10'-0"

Temporary
Water Station
Exact location to
be determined by
utility company

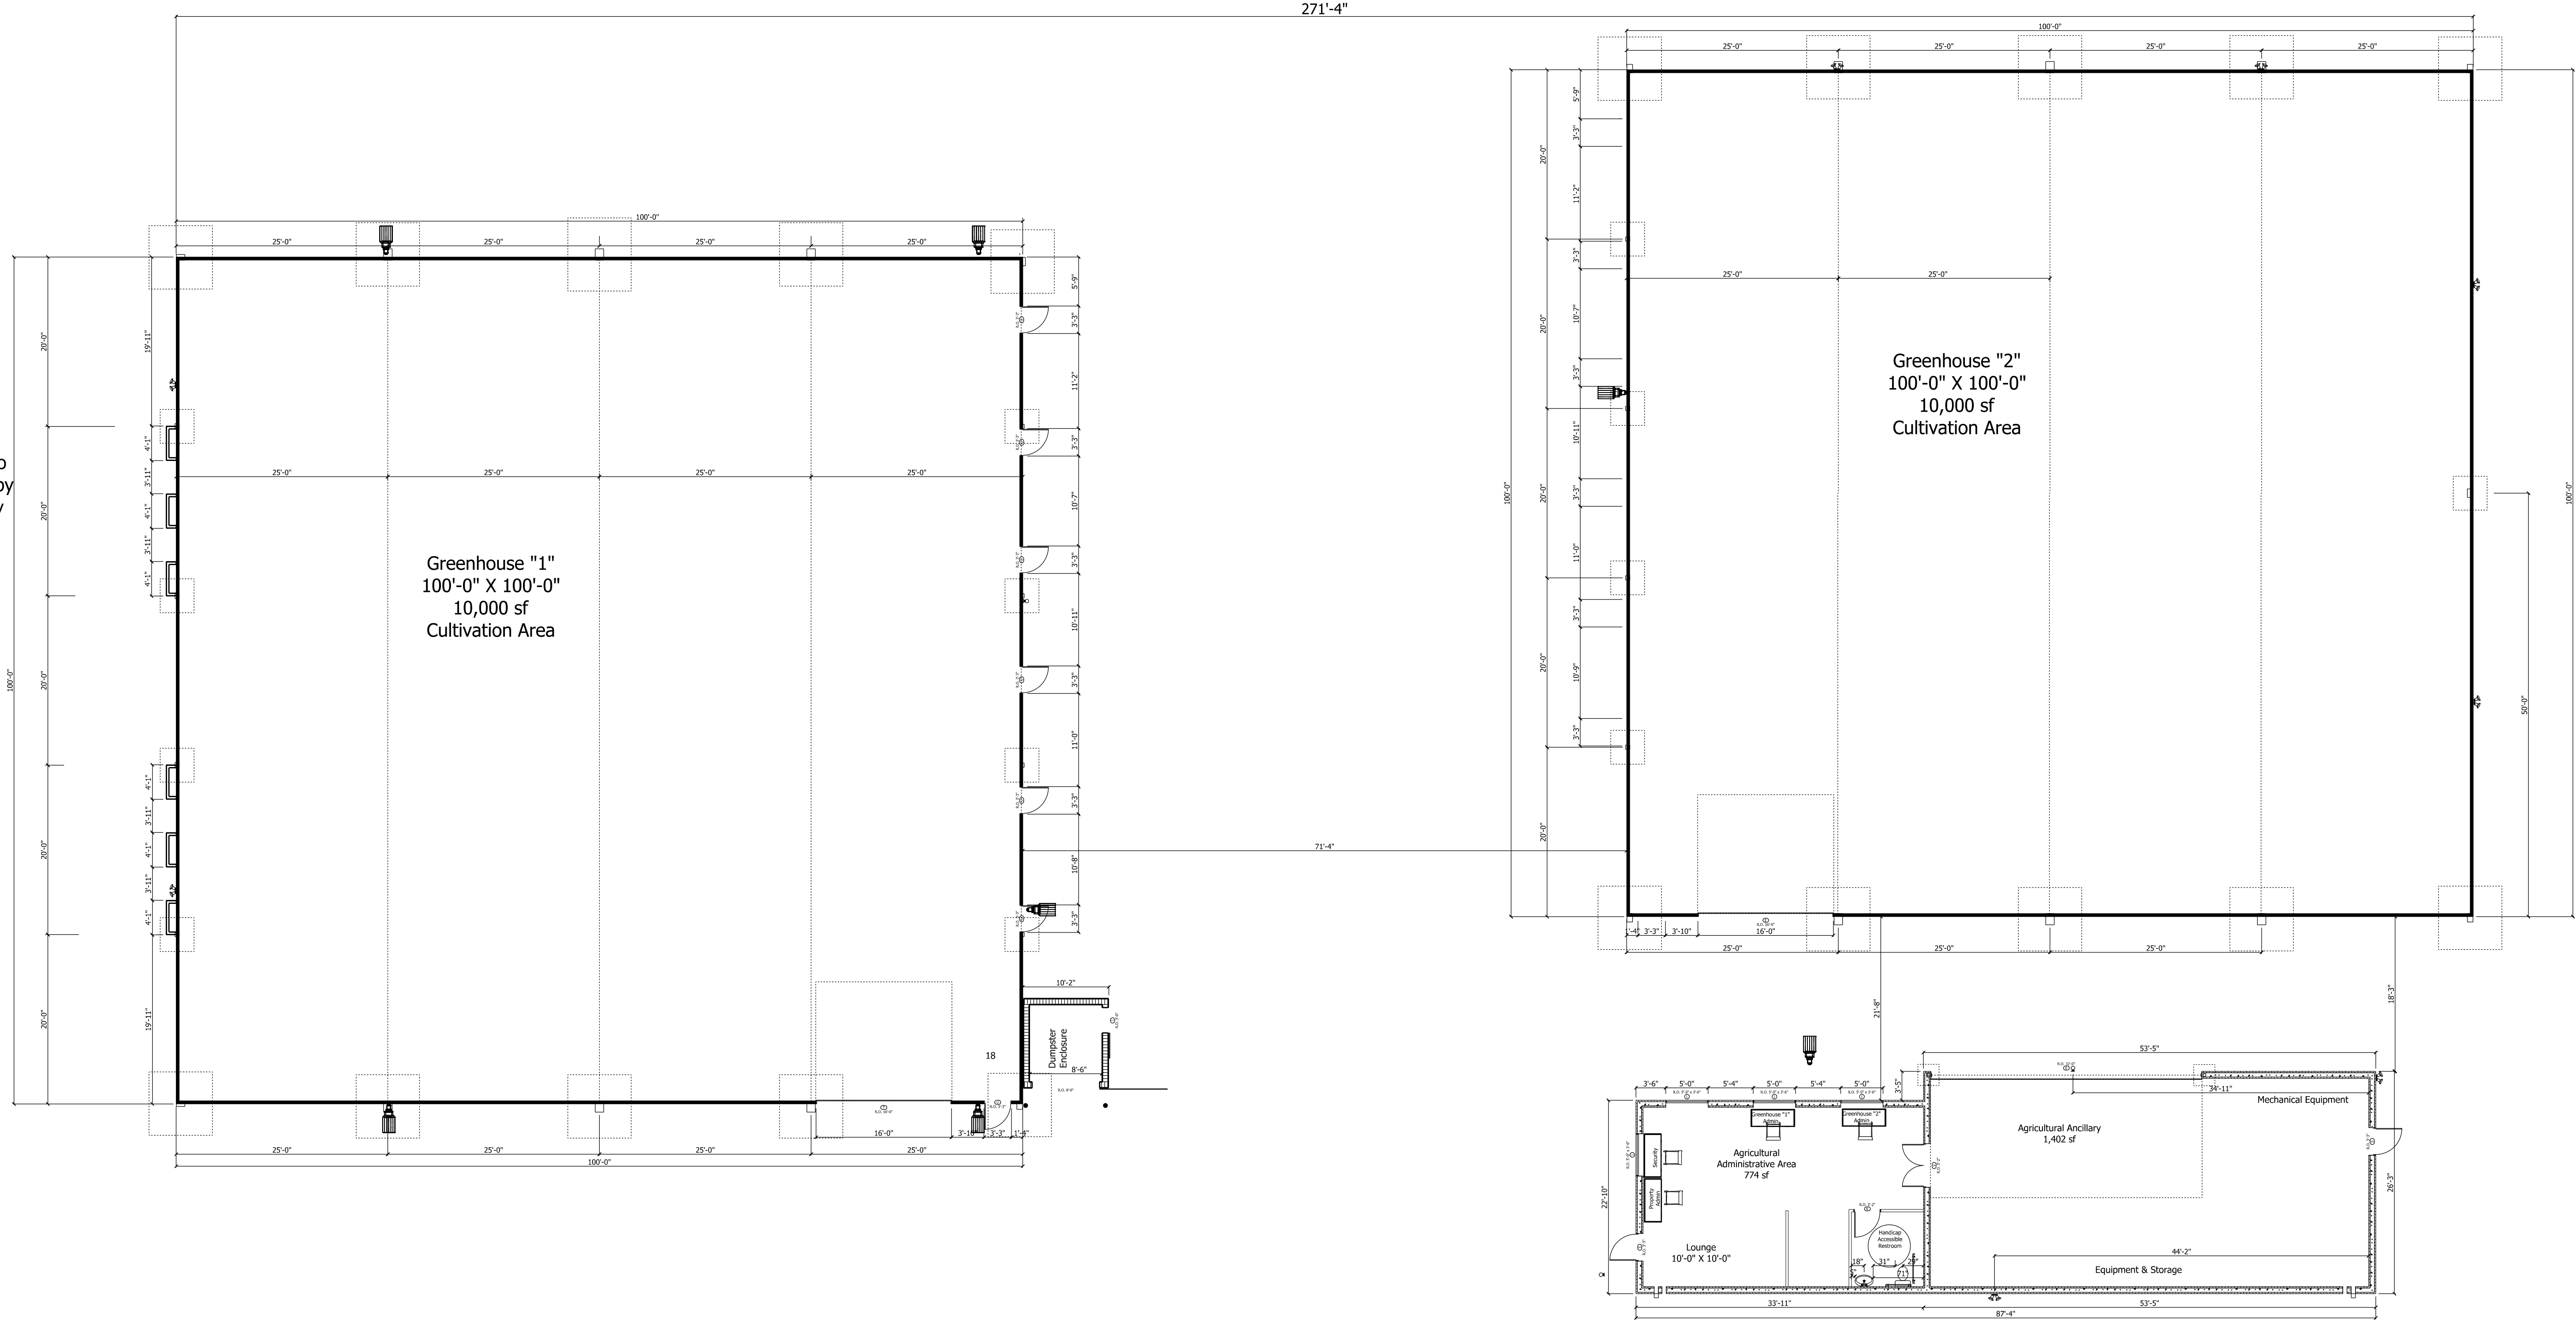

OWNER/APPLICANT

Collective Solutions

15th Ave Between Little
Morongo & Cabot Rd
Desert Hot Springs
CA 92240

CONTACT: Carlos Martell
PHONE: 786-306-4000
Carlos@Martellinc.com

SOFTPLAN
ARCHITECTURAL DESIGN SOFTWARE

Daniel Vergara Architect

8860 Lookout Mountain Ave
Los Angeles, CA 90046
Lic. # C24855

PHONE: (323) 600-5586
FAX:
VERGARAarchitects.com

SCALE: 1" = 10'-0"

DRAWN BY: Carlos Martell

DATE: Wednesday, January 17, 2018

SECTION
LETTER
A
PAGE
NUMBERS
211

APPROVED:

CHECKED BY:

PAGE:

2/11

Floor Plan