


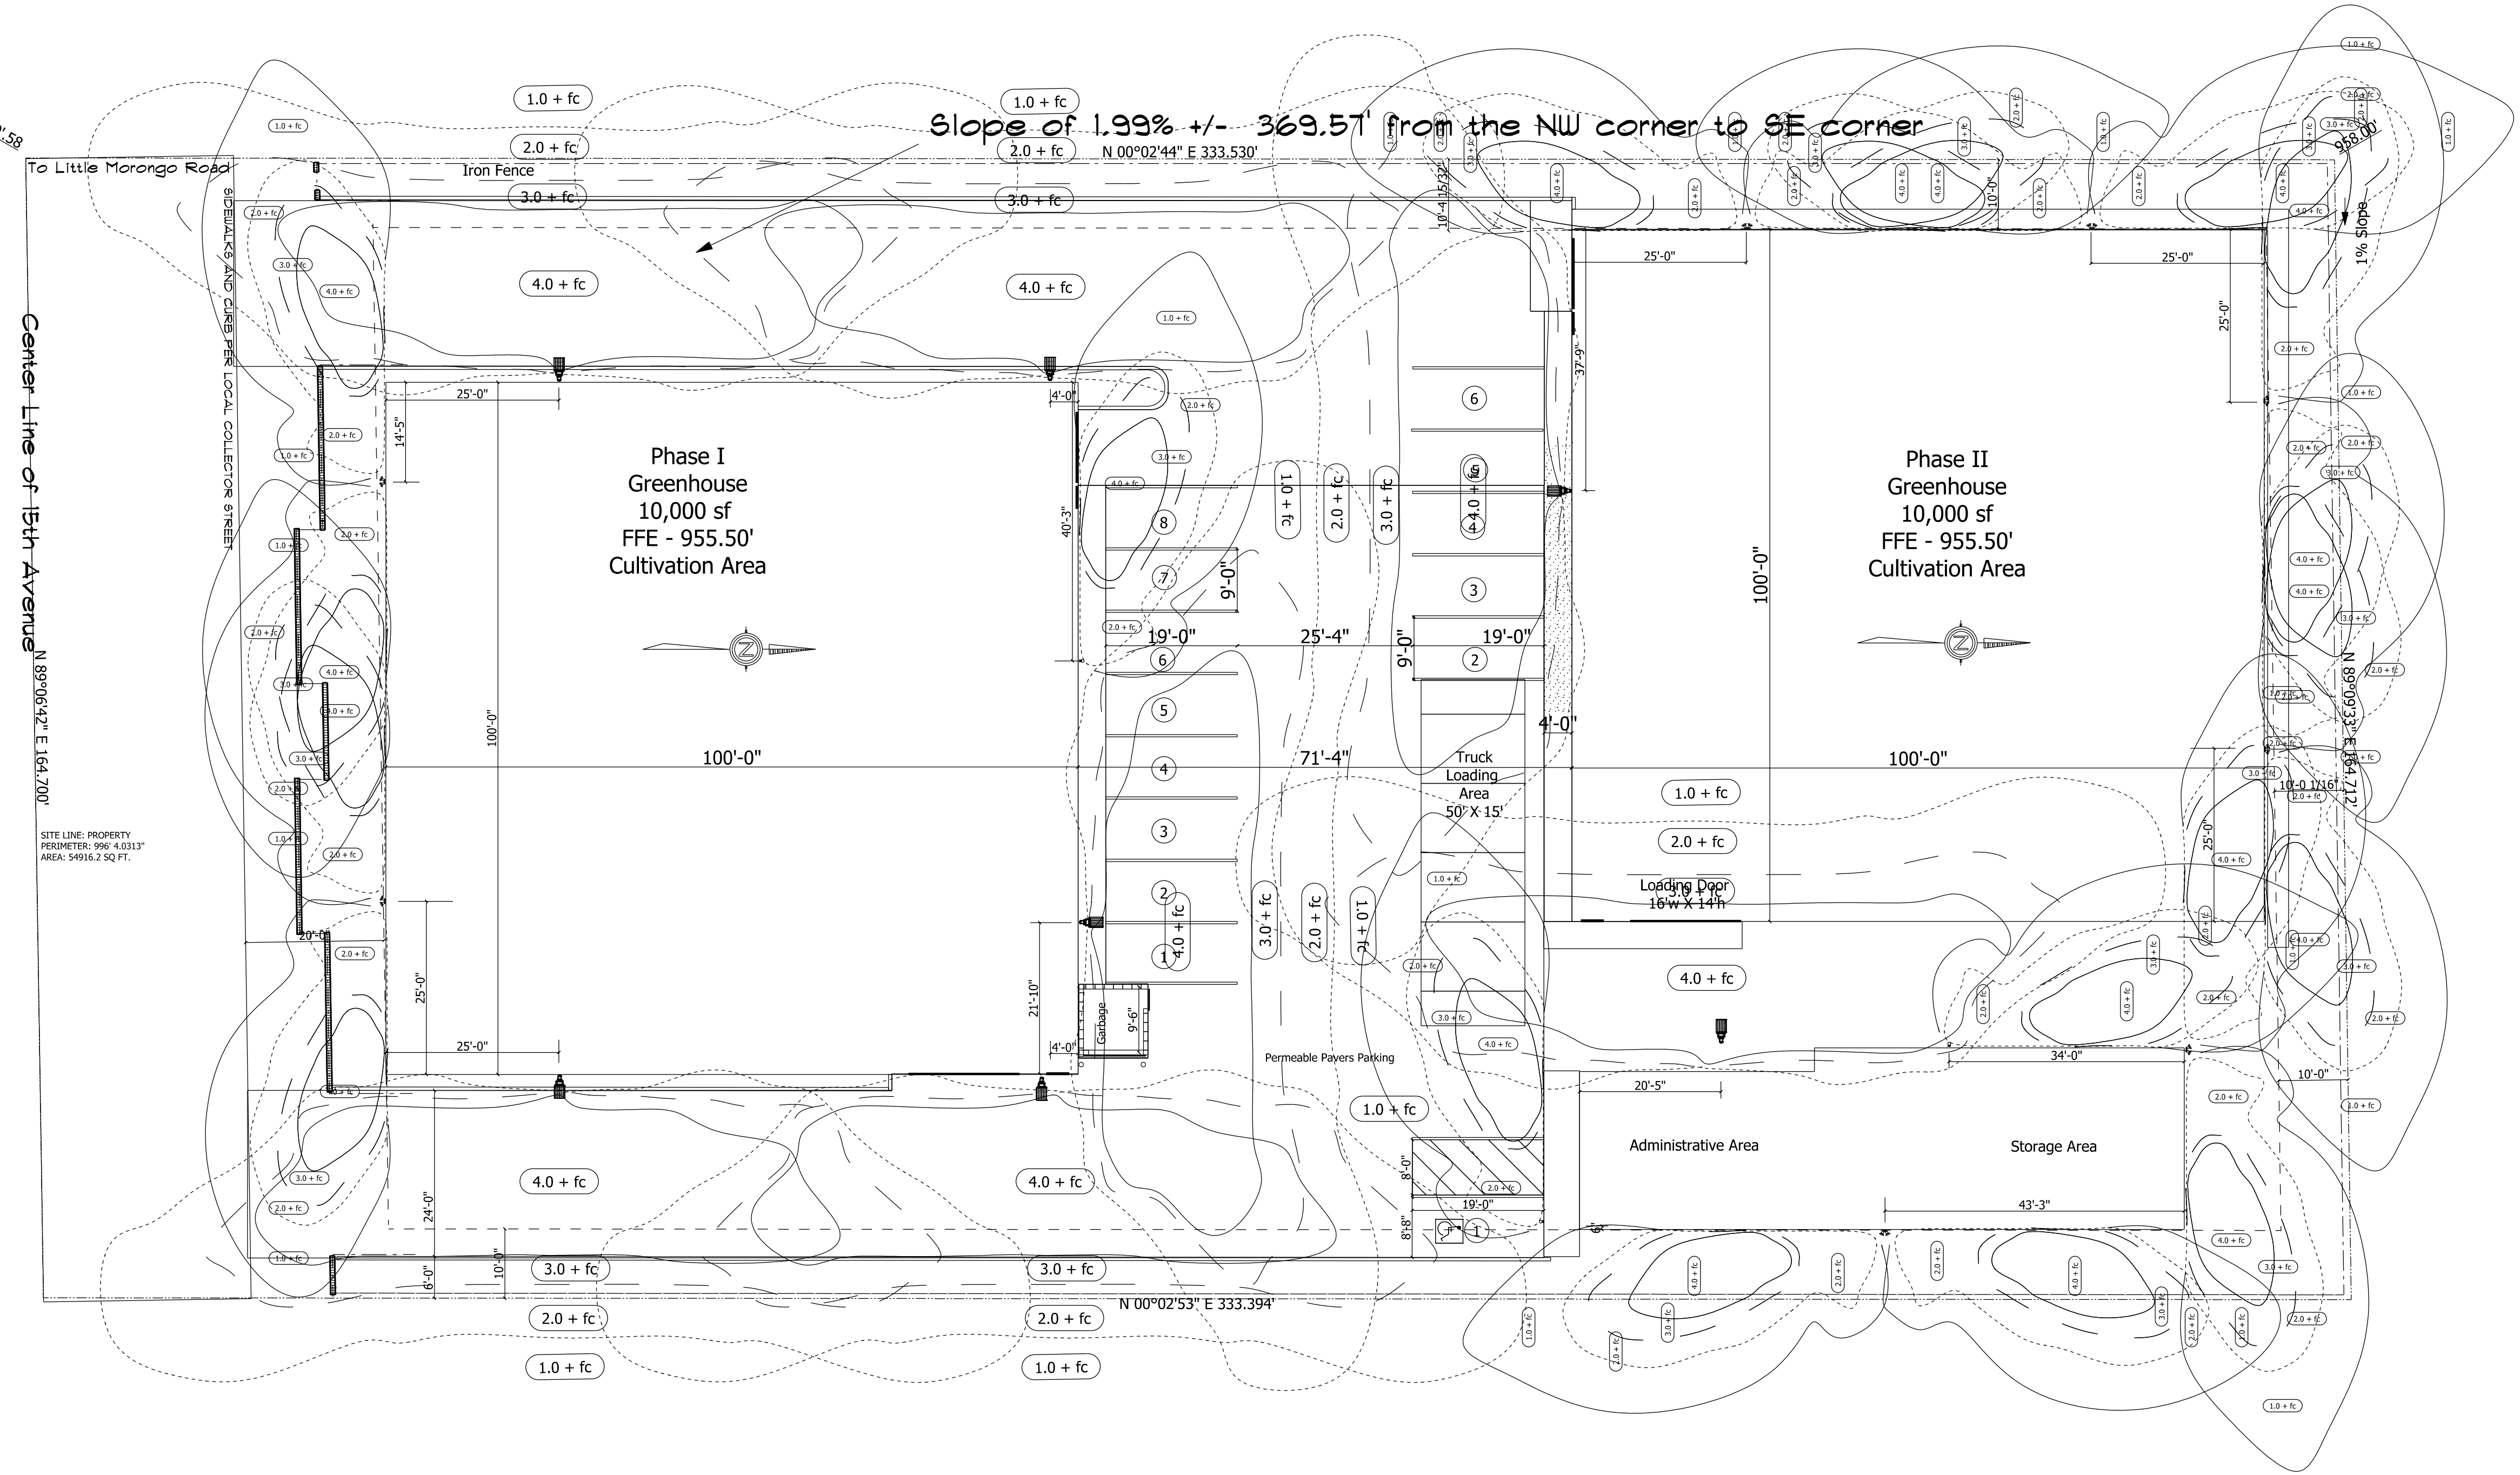

Lighting Plan
SCALE: 1" = 15'-0"