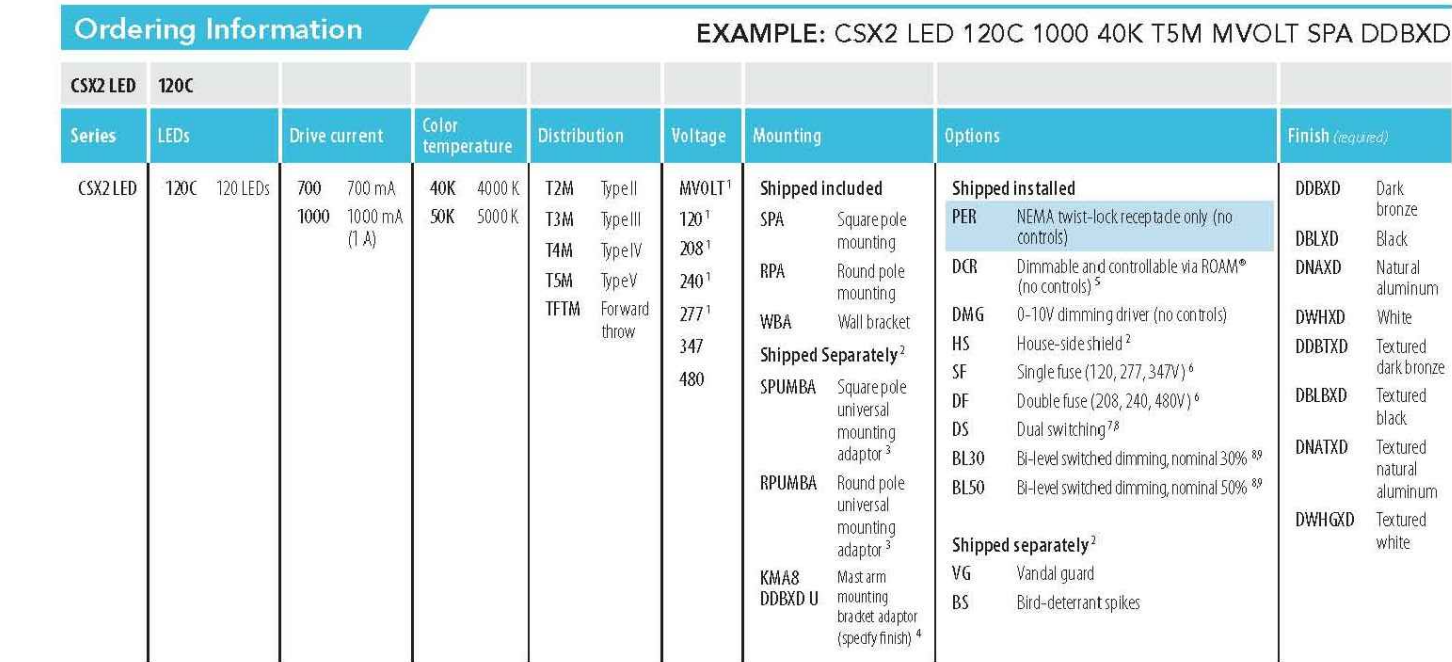


 PARKING LIGHT AND POLE BY LITHONIA LIGHTING
MODEL CSX2 LED 120C 1000 50K TFTM MVOL H6
SINGLE LAMP/ NO TILT, 416 WATTS
DARK BRONZE FINISH
PHOTOMETRIC DIAGRAMS PER MFR VISUAL TEMPLATE TOOLS
20" HIGH

[illegible]

Performance Data

Lumen Output

Lumen output is based on photometric tests performed in accordance with IESNA LM-79-08. Data is condensed to be representative of the range of results that can be achieved in the minimum distance to lighting test. Contact factory for performance data on any configurations not shown here.

Beam Type	Beam Diameter (mm)	Mounting Height (mm)	Cut-off Angle (°)	1000lm (40W, 700K)				1000lm (40W, 4100K)	
				Beam	Height (mm)	Beam	Height (mm)	Beam	Height (mm)
30° MA	1000C-100	3000	360°	12W	20,000	1	1	1	1
				18W	20,000	1	1	1	1
				24W	20,000	1	1	1	1
				36W	20,000	1	1	1	1
				12W	22,500	1	1	1	1
				18W	22,500	1	1	1	1
				24W	22,500	1	1	1	1
				36W	22,500	1	1	1	1
				12W	25,000	1	1	1	1
				18W	25,000	1	1	1	1
				24W	25,000	1	1	1	1
				36W	25,000	1	1	1	1
30° MA	1000C-100	3000	360°	12W	27,500	1	1	1	1
				18W	27,500	1	1	1	1
				24W	27,500	1	1	1	1
				36W	27,500	1	1	1	1
				12W	30,000	1	1	1	1
				18W	30,000	1	1	1	1
				24W	30,000	1	1	1	1
				36W	30,000	1	1	1	1
				12W	32,500	1	1	1	1
				18W	32,500	1	1	1	1
				24W	32,500	1	1	1	1
				36W	32,500	1	1	1	1
30° MA	1000C-100	3000	360°	12W	35,000	1	1	1	1
				18W	35,000	1	1	1	1
				24W	35,000	1	1	1	1
				36W	35,000	1	1	1	1
				12W	37,500	1	1	1	1
				18W	37,500	1	1	1	1
				24W	37,500	1	1	1	1
				36W	37,500	1	1	1	1
				12W	40,000	1	1	1	1
				18W	40,000	1	1	1	1
				24W	40,000	1	1	1	1
				36W	40,000	1	1	1	1
30° MA	1000C-100	3000	360°	12W	42,500	1	1	1	1
				18W	42,500	1	1	1	1
				24W	42,500	1	1	1	1
				36W	42,500	1	1	1	1
				12W	45,000	1	1	1	1
				18W	45,000	1	1	1	1
				24W	45,000	1	1	1	1
				36W	45,000	1	1	1	1
				12W	47,500	1	1	1	1
				18W	47,500	1	1	1	1
				24W	47,500	1	1	1	1
				36W	47,500	1	1	1	1

Lumen Ambient Temperature (LAT) Multipliers

Use these factors to determine the lumen output for average ambient temperatures from 44°F to 104°F (6°C to 40°C).


Ambient	1000lm (40W, 700K)	1000lm (40W, 4100K)
44°F	1.0	1.0
50°F	0.975	0.975
56°F	0.95	0.95
62°F	0.925	0.925
68°F	0.9	0.9
74°F	0.875	0.875
80°F	0.85	0.85
86°F	0.825	0.825
92°F	0.8	0.8
98°F	0.775	0.775
104°F	0.75	0.75

Projected LED Lifetime

Based on the industry standard of 30,000 hours for CRI > 90 LED life at 24°C ambient. Based on 10,000 hours for CRI < 90 LED life at 24°C ambient. Based on 10,000 hours for CRI < 90 LED life at 24°C ambient. Based on 10,000 hours for CRI < 90 LED life at 24°C ambient.

To calculate LUX for the lumen maintenance factor that corresponds to the desired number of hours of operation, please refer to the following lumen maintenance values, contact factory.

Operating hours	0	25,000	50,000	100,000
Lumen Maintenance Factor	1.0	0.94	0.90	0.85

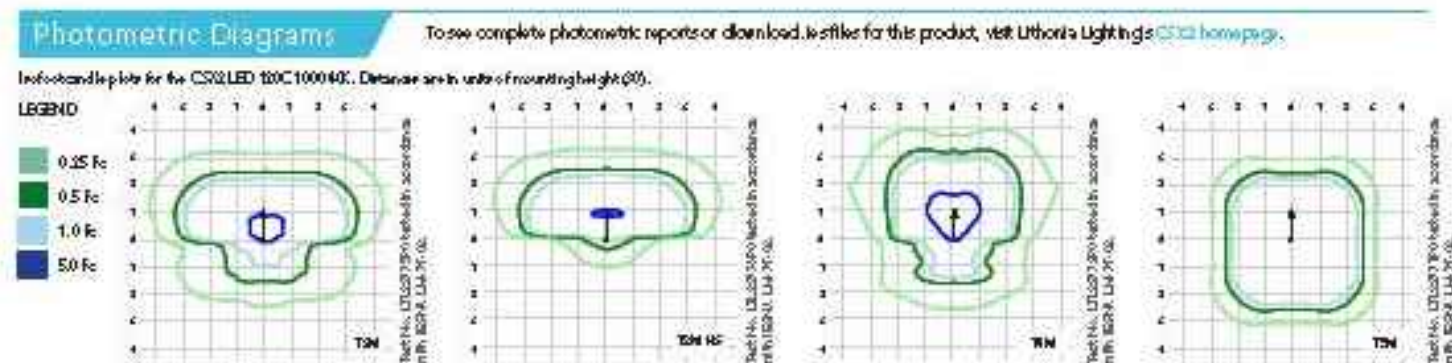

FEATURES & SPECIFICATIONS

REFERENCE

The Canon CR-EHD is an enhanced edition of the standard electronic rangefinder and autoexposure camera. It is a 35mm SLR with a 135mm f/2.8 ED ultralight telephoto lens.

CONSTRUCTION

Single frame of 36 exposing frames is unique for telephoto lens that allows complete optical viewfinder coverage of the entire frame. The Canon CR-EHD is a rugged, compact camera with a 135mm f/2.8 ED ultralight telephoto lens. The lens is made of 12 elements in 8 groups, with 10 aspherical lens surfaces. The lens is made of 12 elements in 8 groups, with 10 aspherical lens surfaces. The lens is made of 12 elements in 8 groups, with 10 aspherical lens surfaces.

VIEW

Single frame of 36 exposing frames is unique for telephoto lens that allows complete optical viewfinder coverage of the entire frame. The Canon CR-EHD is a rugged, compact camera with a 135mm f/2.8 ED ultralight telephoto lens. The lens is made of 12 elements in 8 groups, with 10 aspherical lens surfaces. The lens is made of 12 elements in 8 groups, with 10 aspherical lens surfaces.

OPTICS

Single frame of 36 exposing frames is unique for telephoto lens that allows complete optical viewfinder coverage of the entire frame. The Canon CR-EHD is a rugged, compact camera with a 135mm f/2.8 ED ultralight telephoto lens. The lens is made of 12 elements in 8 groups, with 10 aspherical lens surfaces. The lens is made of 12 elements in 8 groups, with 10 aspherical lens surfaces.

FEATURES

Single frame of 36 exposing frames is unique for telephoto lens that allows complete optical viewfinder coverage of the entire frame. The Canon CR-EHD is a rugged, compact camera with a 135mm f/2.8 ED ultralight telephoto lens. The lens is made of 12 elements in 8 groups, with 10 aspherical lens surfaces. The lens is made of 12 elements in 8 groups, with 10 aspherical lens surfaces.

CONSTRUCTION


Single frame of 36 exposing frames is unique for telephoto lens that allows complete optical viewfinder coverage of the entire frame. The Canon CR-EHD is a rugged, compact camera with a 135mm f/2.8 ED ultralight telephoto lens. The lens is made of 12 elements in 8 groups, with 10 aspherical lens surfaces. The lens is made of 12 elements in 8 groups, with 10 aspherical lens surfaces.

VIEW


Single frame of 36 exposing frames is unique for telephoto lens that allows complete optical viewfinder coverage of the entire frame. The Canon CR-EHD is a rugged, compact camera with a 135mm f/2.8 ED ultralight telephoto lens. The lens is made of 12 elements in 8 groups, with 10 aspherical lens surfaces. The lens is made of 12 elements in 8 groups, with 10 aspherical lens surfaces.

OPTICS

Single frame of 36 exposing frames is unique for telephoto lens that allows complete optical viewfinder coverage of the entire frame. The Canon CR-EHD is a rugged, compact camera with a 135mm f/2.8 ED ultralight telephoto lens. The lens is made of 12 elements in 8 groups, with 10 aspherical lens surfaces. The lens is made of 12 elements in 8 groups, with 10 aspherical lens surfaces.

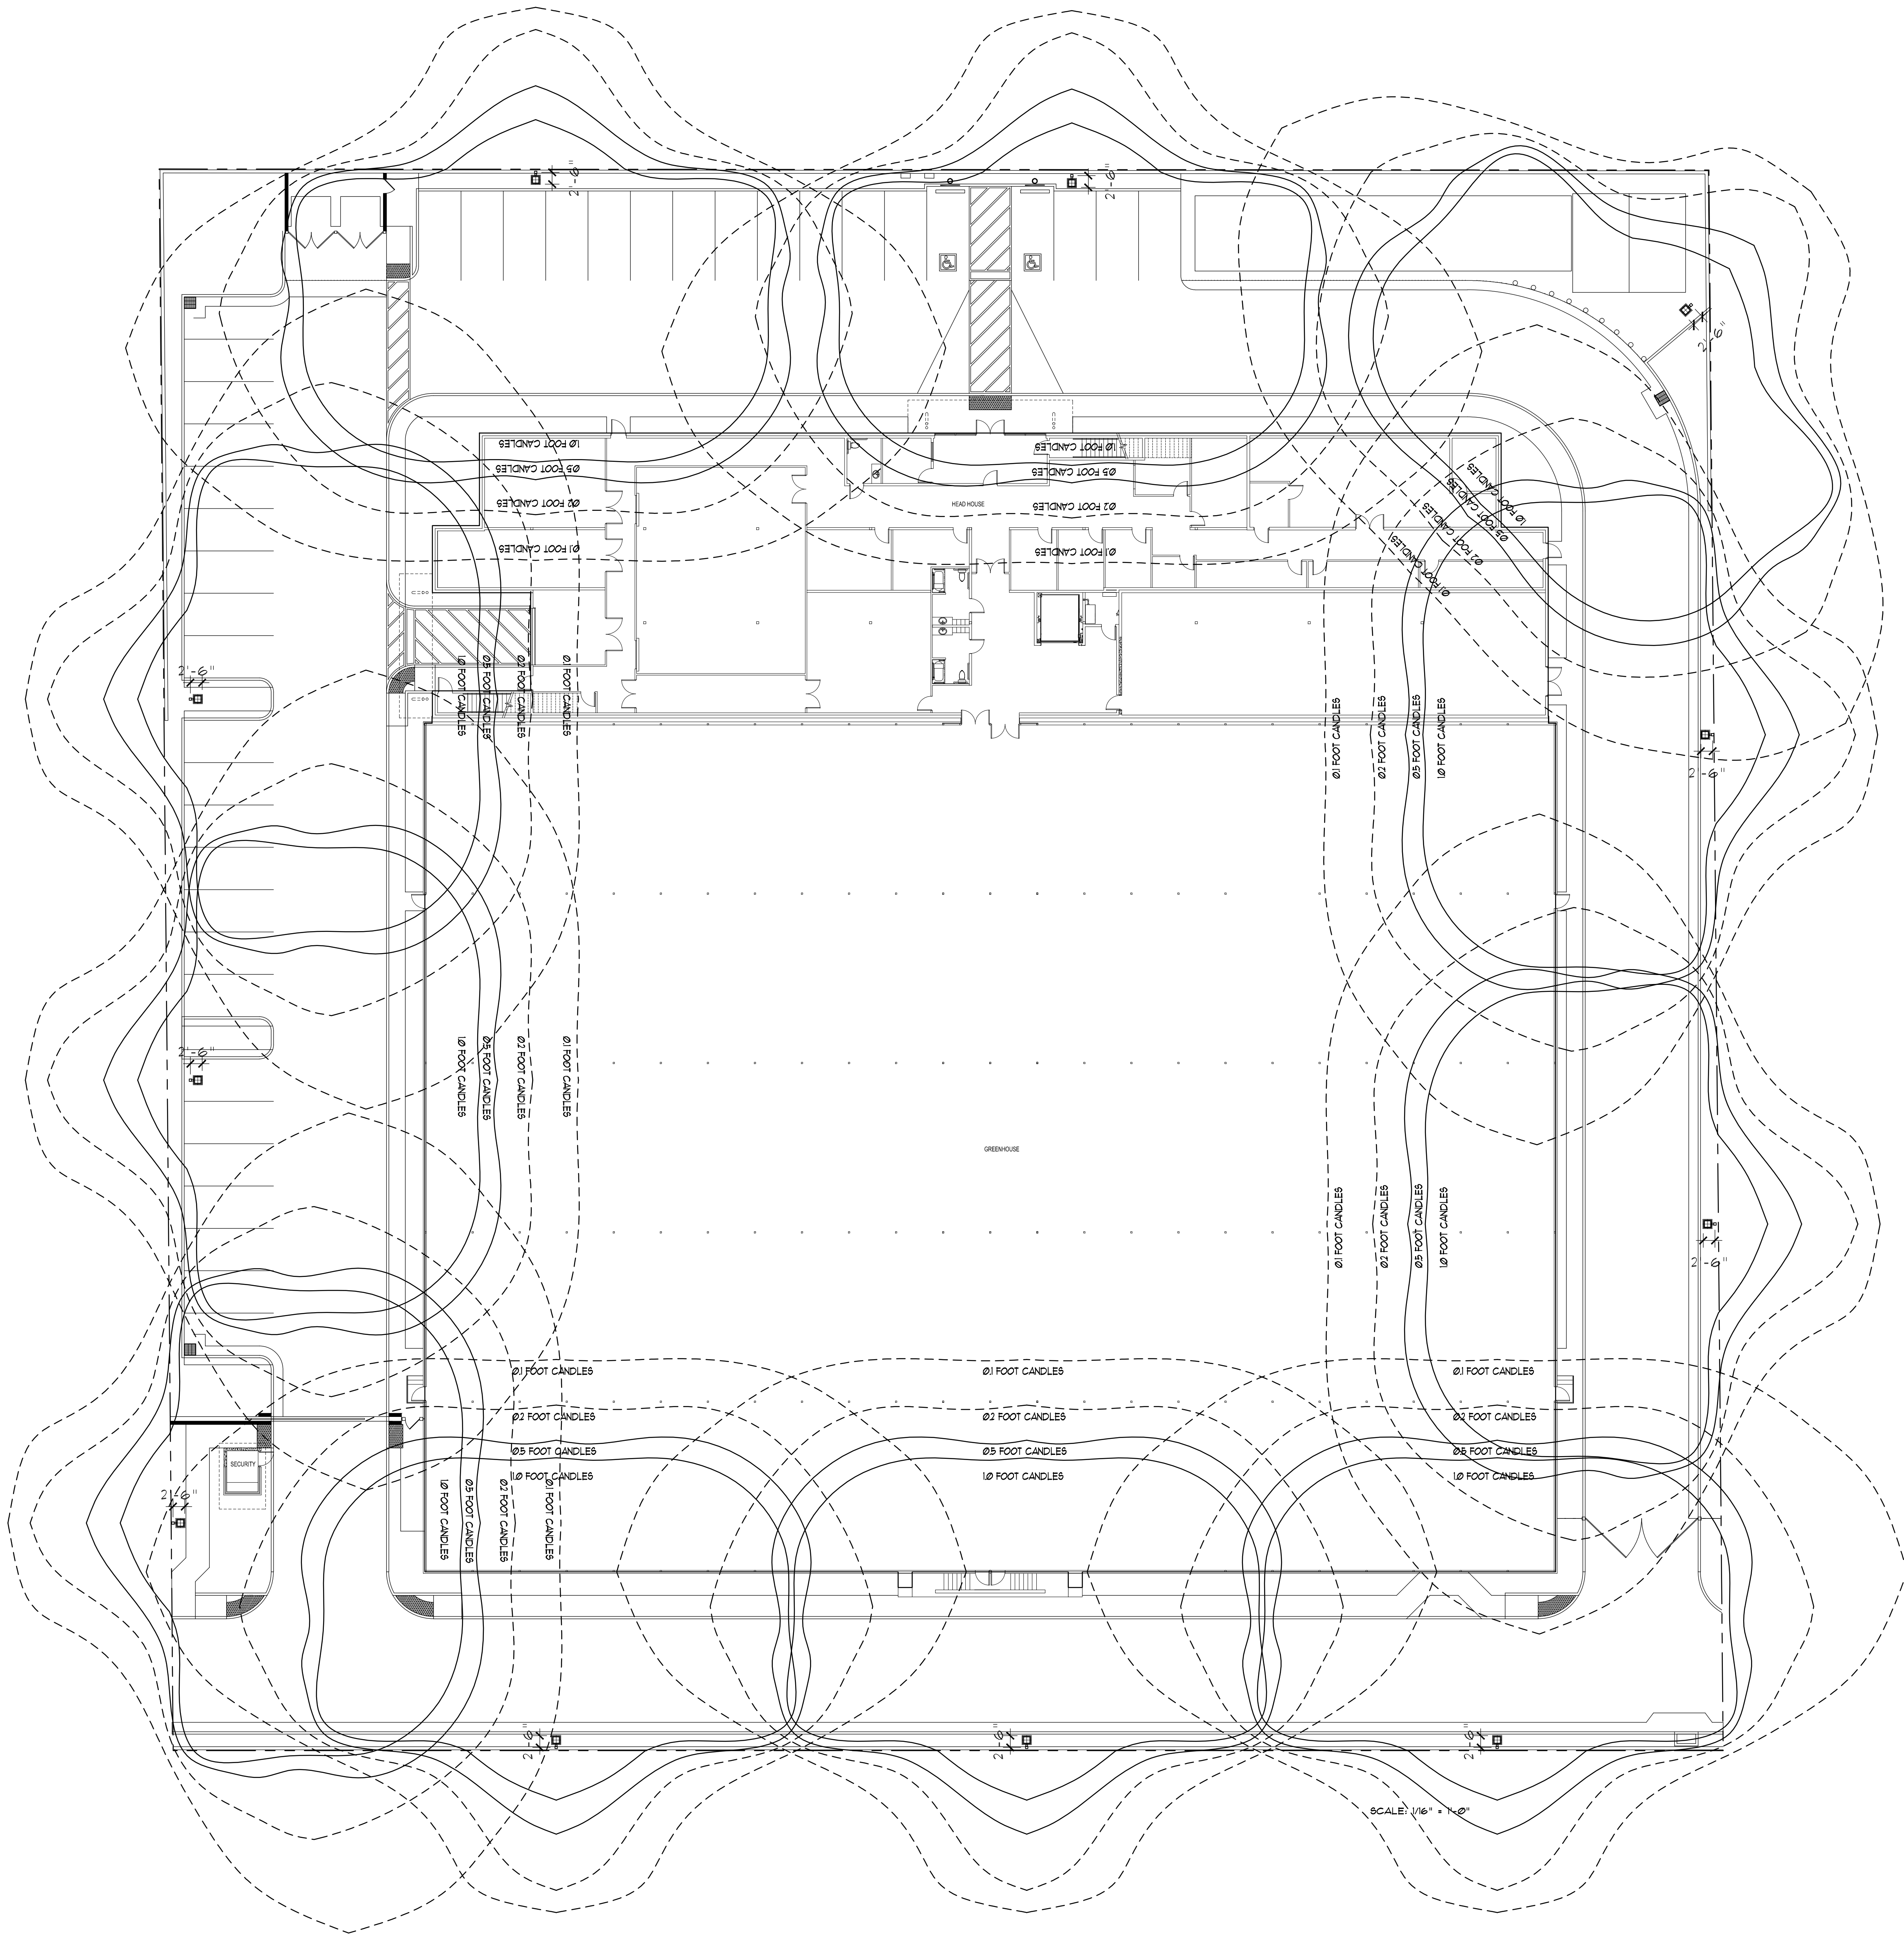


PROPOSED SITE LIGHTING PLAN

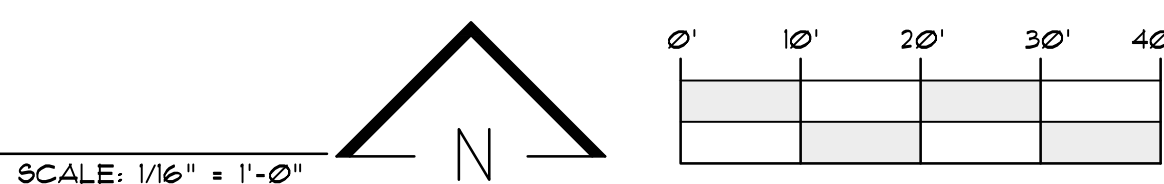

**NEW BUILDING FOR:
GREEN BOND LLC.
A.P.N. : 663-280-002
DESERT HOT SPRINGS, CALIFORNIA**

Cioffi
ARCHITECT

JAMES CIOFFI ARCHITECT
A CALIFORNIA CORPORATION
2121 E. TAHQUITZ CANYON WAY - SUITE 3
PALM SPRINGS, CALIFORNIA 92262
TELEPHONE 760-325-1557

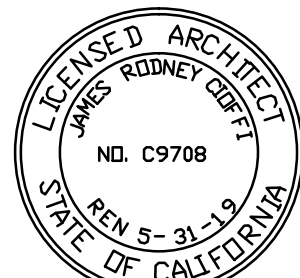

Δ	REVISION
Δ	////////////////

SCALE: 1/16" = 1'-0"

PROJECT NO: 1717

FILE: 1717-GBSLTG

S H E E T

SL-1.1