




PUBLIC ART DISPLAY

30

CABOT ROAD

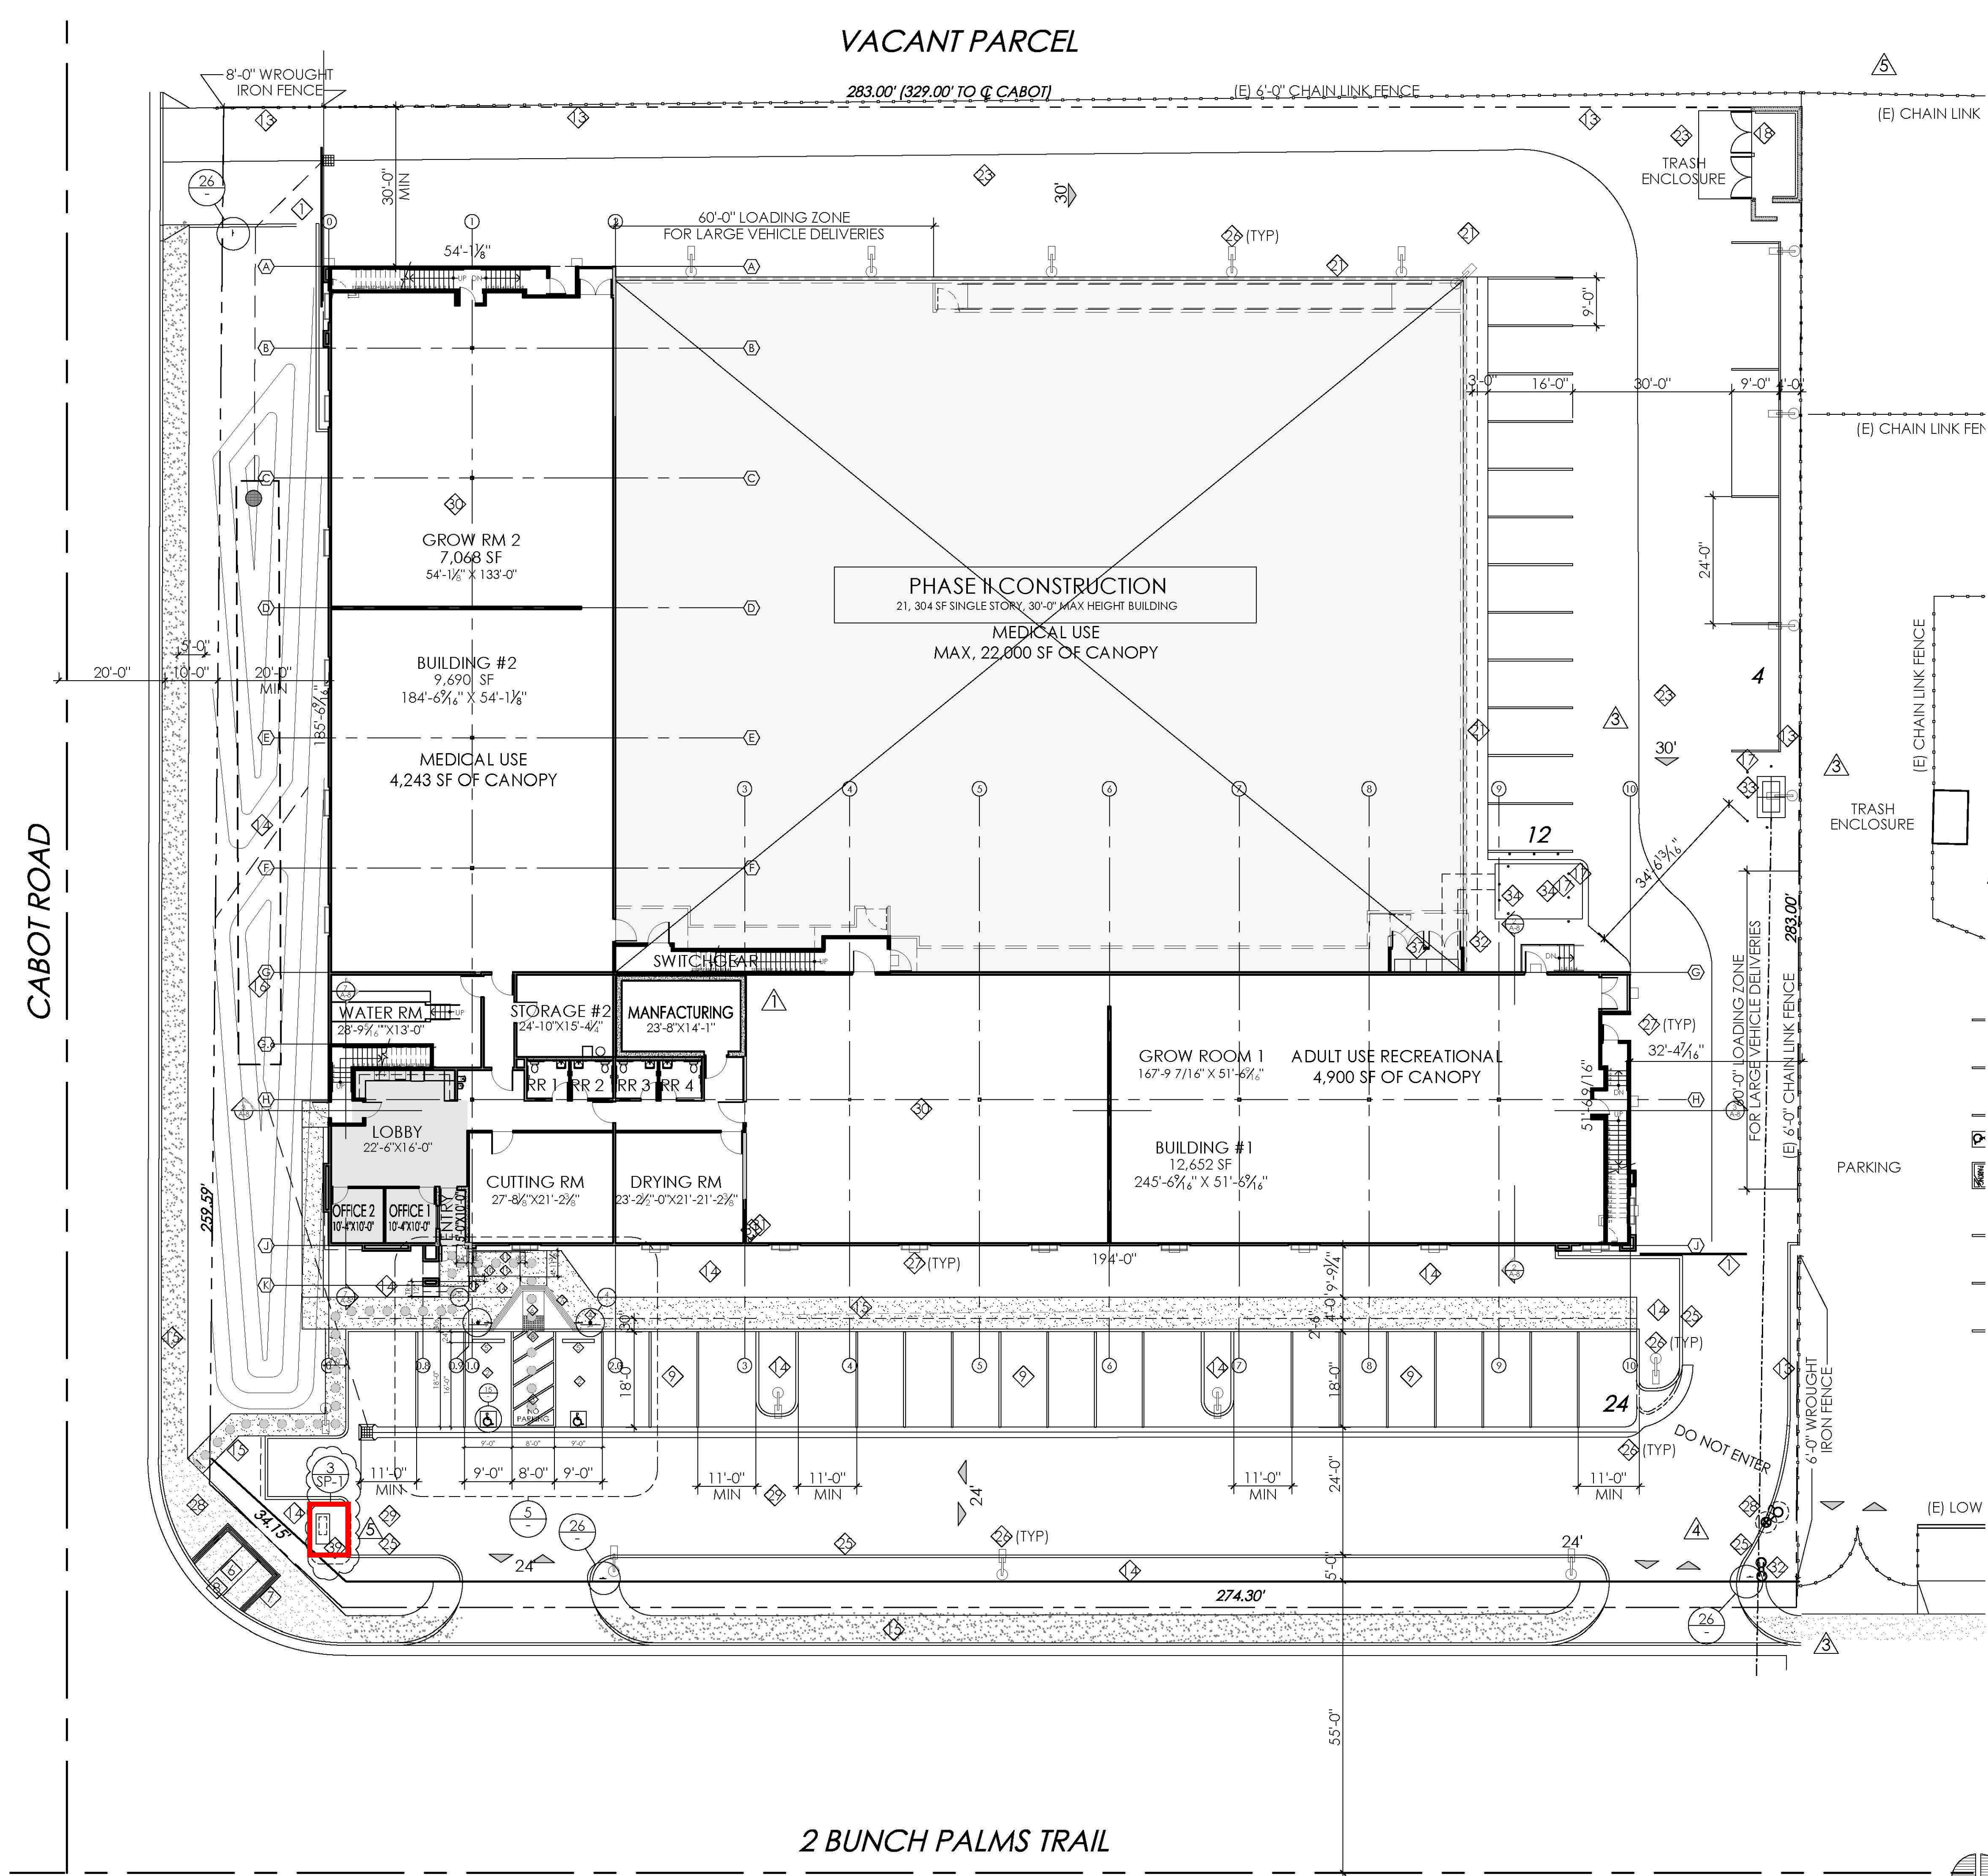


2 BUNCH PALMS TRAIL

SITE PLAN SC 3/16"=1'-0"


- 1 ROLLING SECURITY GATE
- 2 ACCESSIBLE VAN STALL
- 3 LOADING ZONE
- 4 SIGNAGE
- 5 CONC. WHEEL STOP
- 6 CURB RAMP
- 7 WARNING GROOVES
- 8 TRUNCATED DOMES
- 9 STANDARD STALL
- 10 RAMP
- 11 1/2" STEEL RAILS
- 12 CONC. STEP W/ WARNING GROOVES
- 13 6'-0" WROUGHT IRON SECURITY FENCE
- 14 PLANTER
- 15 CONC. WALKWAY
- 16 RETENTION TANK
- 17 STEEL BOLLARD
- 18 TRASH ENCLOSURE
- 19 NOT USED
- 20 NOT USED
- 21 RETAINING WALL
- 22 CONCRETE PAD
- 23 ACCESS ROAD
- 24 TRANSFORMER
- 25 CONCRETE CURB
- 26 15'-0" TALL LIGHT STANDARD W/ CONCRETE BASE
- 27 ESPALIER
- 28 (E) FIRE HYDRANT
- 29 ASPHALT PARKING LOT
- 30 BUILDING
- 31 SPRINKLER RISER
- 32 500 GALLON PROPANE TANK
- 33 TRANSFER SWITCH
- 34 EDISON VAULT
- 35 EDISON FEEDER LINE
- 36 TRENCH GUTTER
- 37 SWITCHGEAR
- 38 DBL CHECK DETECTOR VALVE
- 39 SITE ARTWORK BUCKING STALLION SCULPTURE
WEIGHT 250 LBS
HEIGHT 12'-0"
BASE PLATE 30'X68"

SITE PLAN KEY NOTES

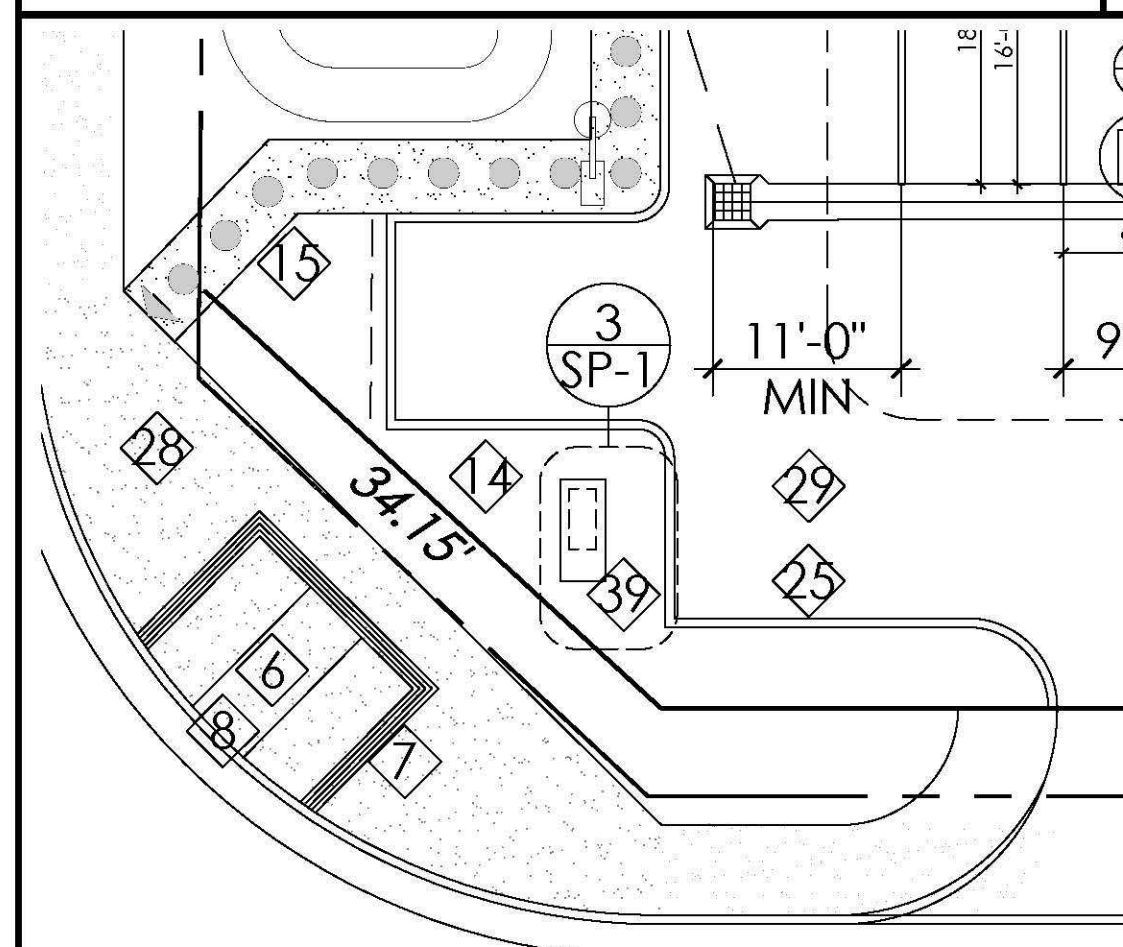


PUBLIC ART DISPLAY SC 3/32"=1'-0"

© 2018 WMA / WILLIAM MASON ARCHITECT, INC.

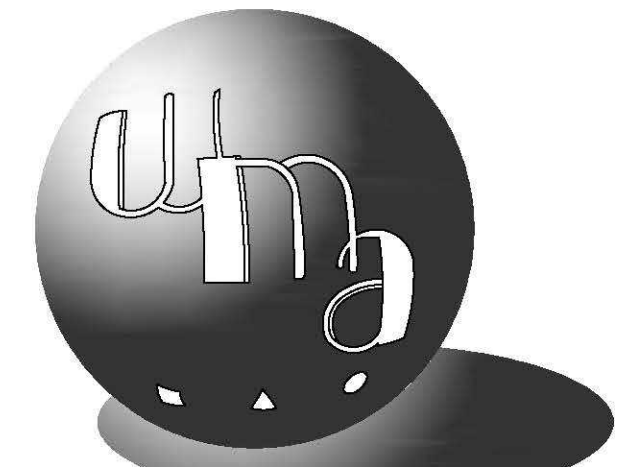

ARCHITECTURE PLANNING INTERIORS
WILLIAM MASON, ARCHITECT INC.
3276 DAKOTA AVENUE
COSTA MESA, CALIFORNIA 92626
714.427.0688 FAX: 714.724.3990
EMAIL: Bill@WilliamMasonArchitect.com

ARCHITECT'S STAMP

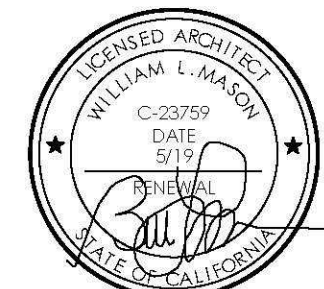

CONSULTANT'S STAMP

△	DATE	REVISION
△	8/31/17	PLAN CHECK CORRECTIONS
△	10/18/17	PLAN CHECK CORRECTIONS
△	1/10/18	EDISON REVISIONS
△	2/1/18	DRIVEWAY REVISIONS
△	4/1/18	SITE ARTWORK
△	4/11/18	TRASH ENCLOSURE EDISON REV.

OWNER

BUNCH PALMS TRAIL, LLC

(951)640-7392

PROJECT:

DESERT HOT SPRINGS GROW

APN# 665-030-058
65401 TWO BUNCH TRAILS
DESERT HOT SPRINGS, CA 92240
CONDITIONAL USE PERMIT 03-15

PROJECT NO. 15.004.00

SCALE: AS NOTED

DATE: 6/6/17

DRAWN BY:

REVIEWED BY:

ISSUED FOR BID

ISSUED FOR CONST.

SHEET TITLE:

ART DISPLAY SITE PLAN
KEY NOTES
and
DETAILS

SHEET NO.

SD-1

5

10

15

20

25