

EOR STAMP

PROJECT:

ISSUANCE:

REVISIONS

#	DATE	DESCRIPTION
---	------	-------------

DATE: 11/5/2018

PROJECT NUMBER
18.PGEC.001

DRAWN BY:
GL


CHECKED BY:	FR
-------------	----

SHEET TITLE:

ELECTRICAL SITE PLAN

SHEET NO:

E1.0

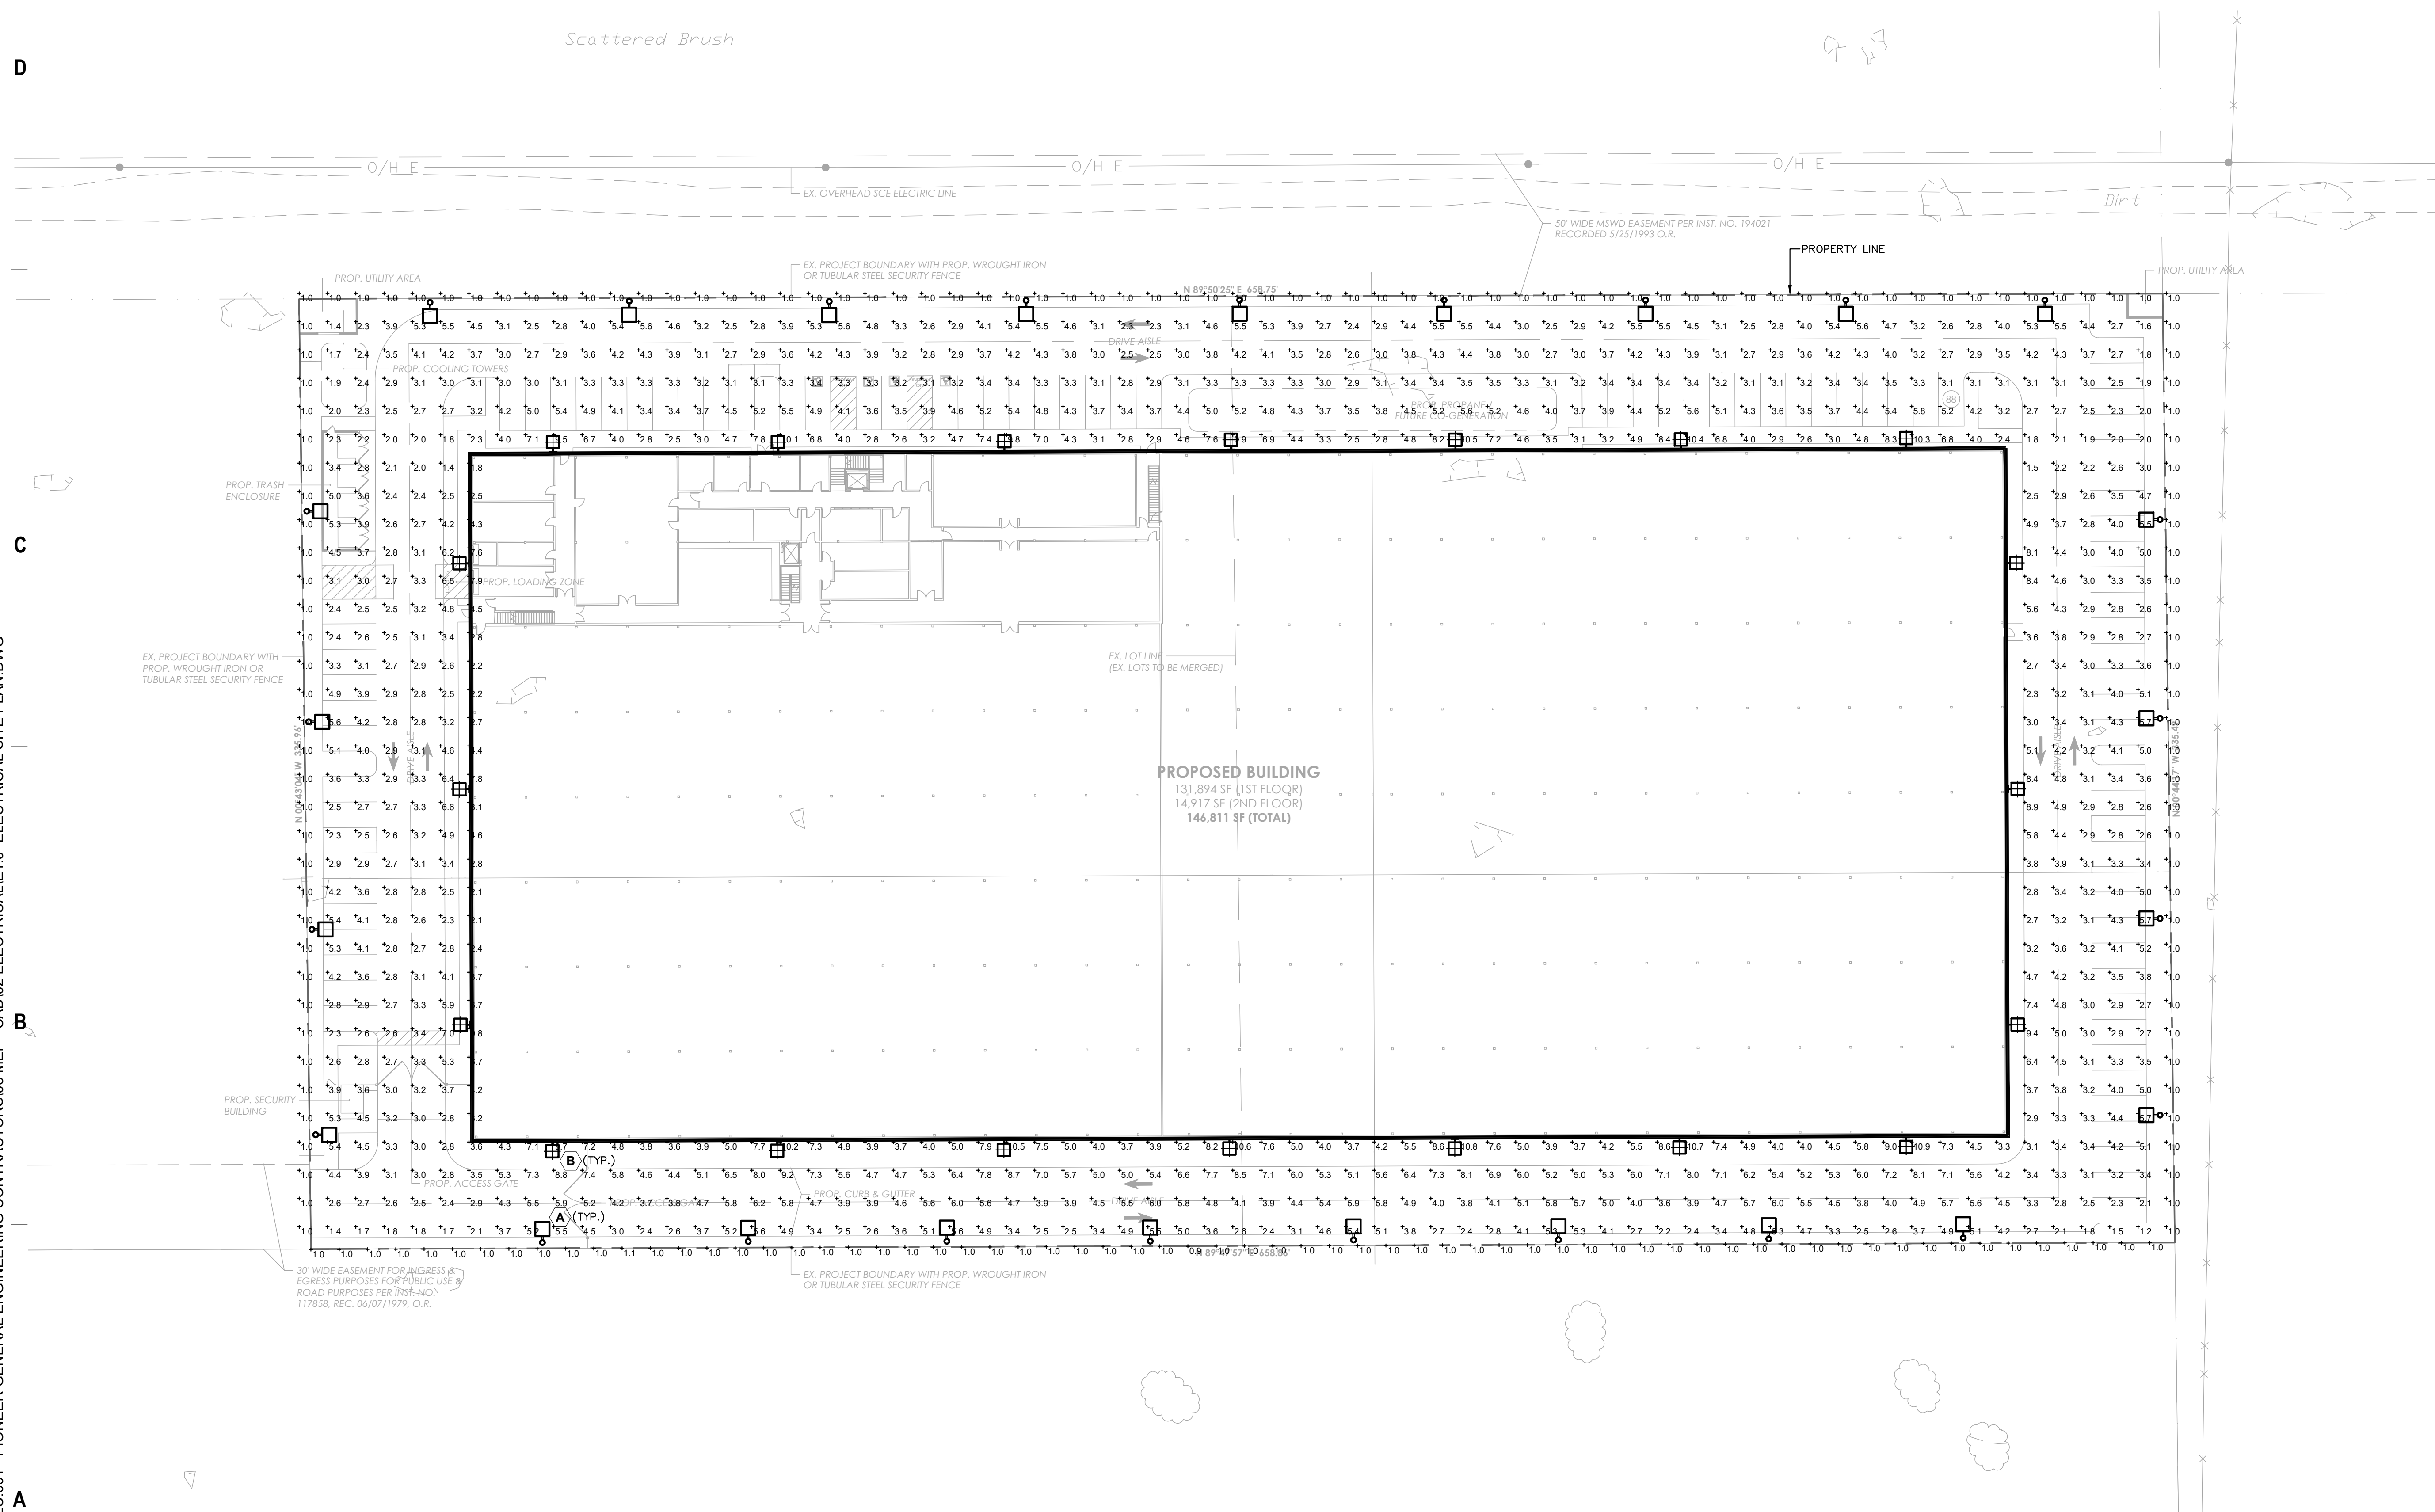

ELECTRICAL SITE PLAN

1"=30'-0"

