


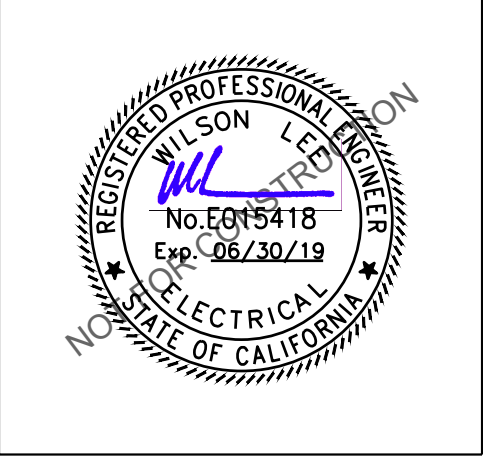

ACIES
ENGINEERING
3371 Olcott Street
Santa Clara, CA 95054
ph: (408) 522-5255
fx: (408) 522-5260
info@acies.net
Copyright © 2018

BEST DEVELOPMENT GROUP	APN: 656-020-034 DESERT HOT SPRINGS, CA 92240
-----------------------------------	--


[illegible]

DATE:	
DRAWN BY:	JBE
CHECKED BY:	NGE
JOB #	

**ELECTRICAL
PHOTOMETRIC PLAN**

SHEET NO.

EP1.0

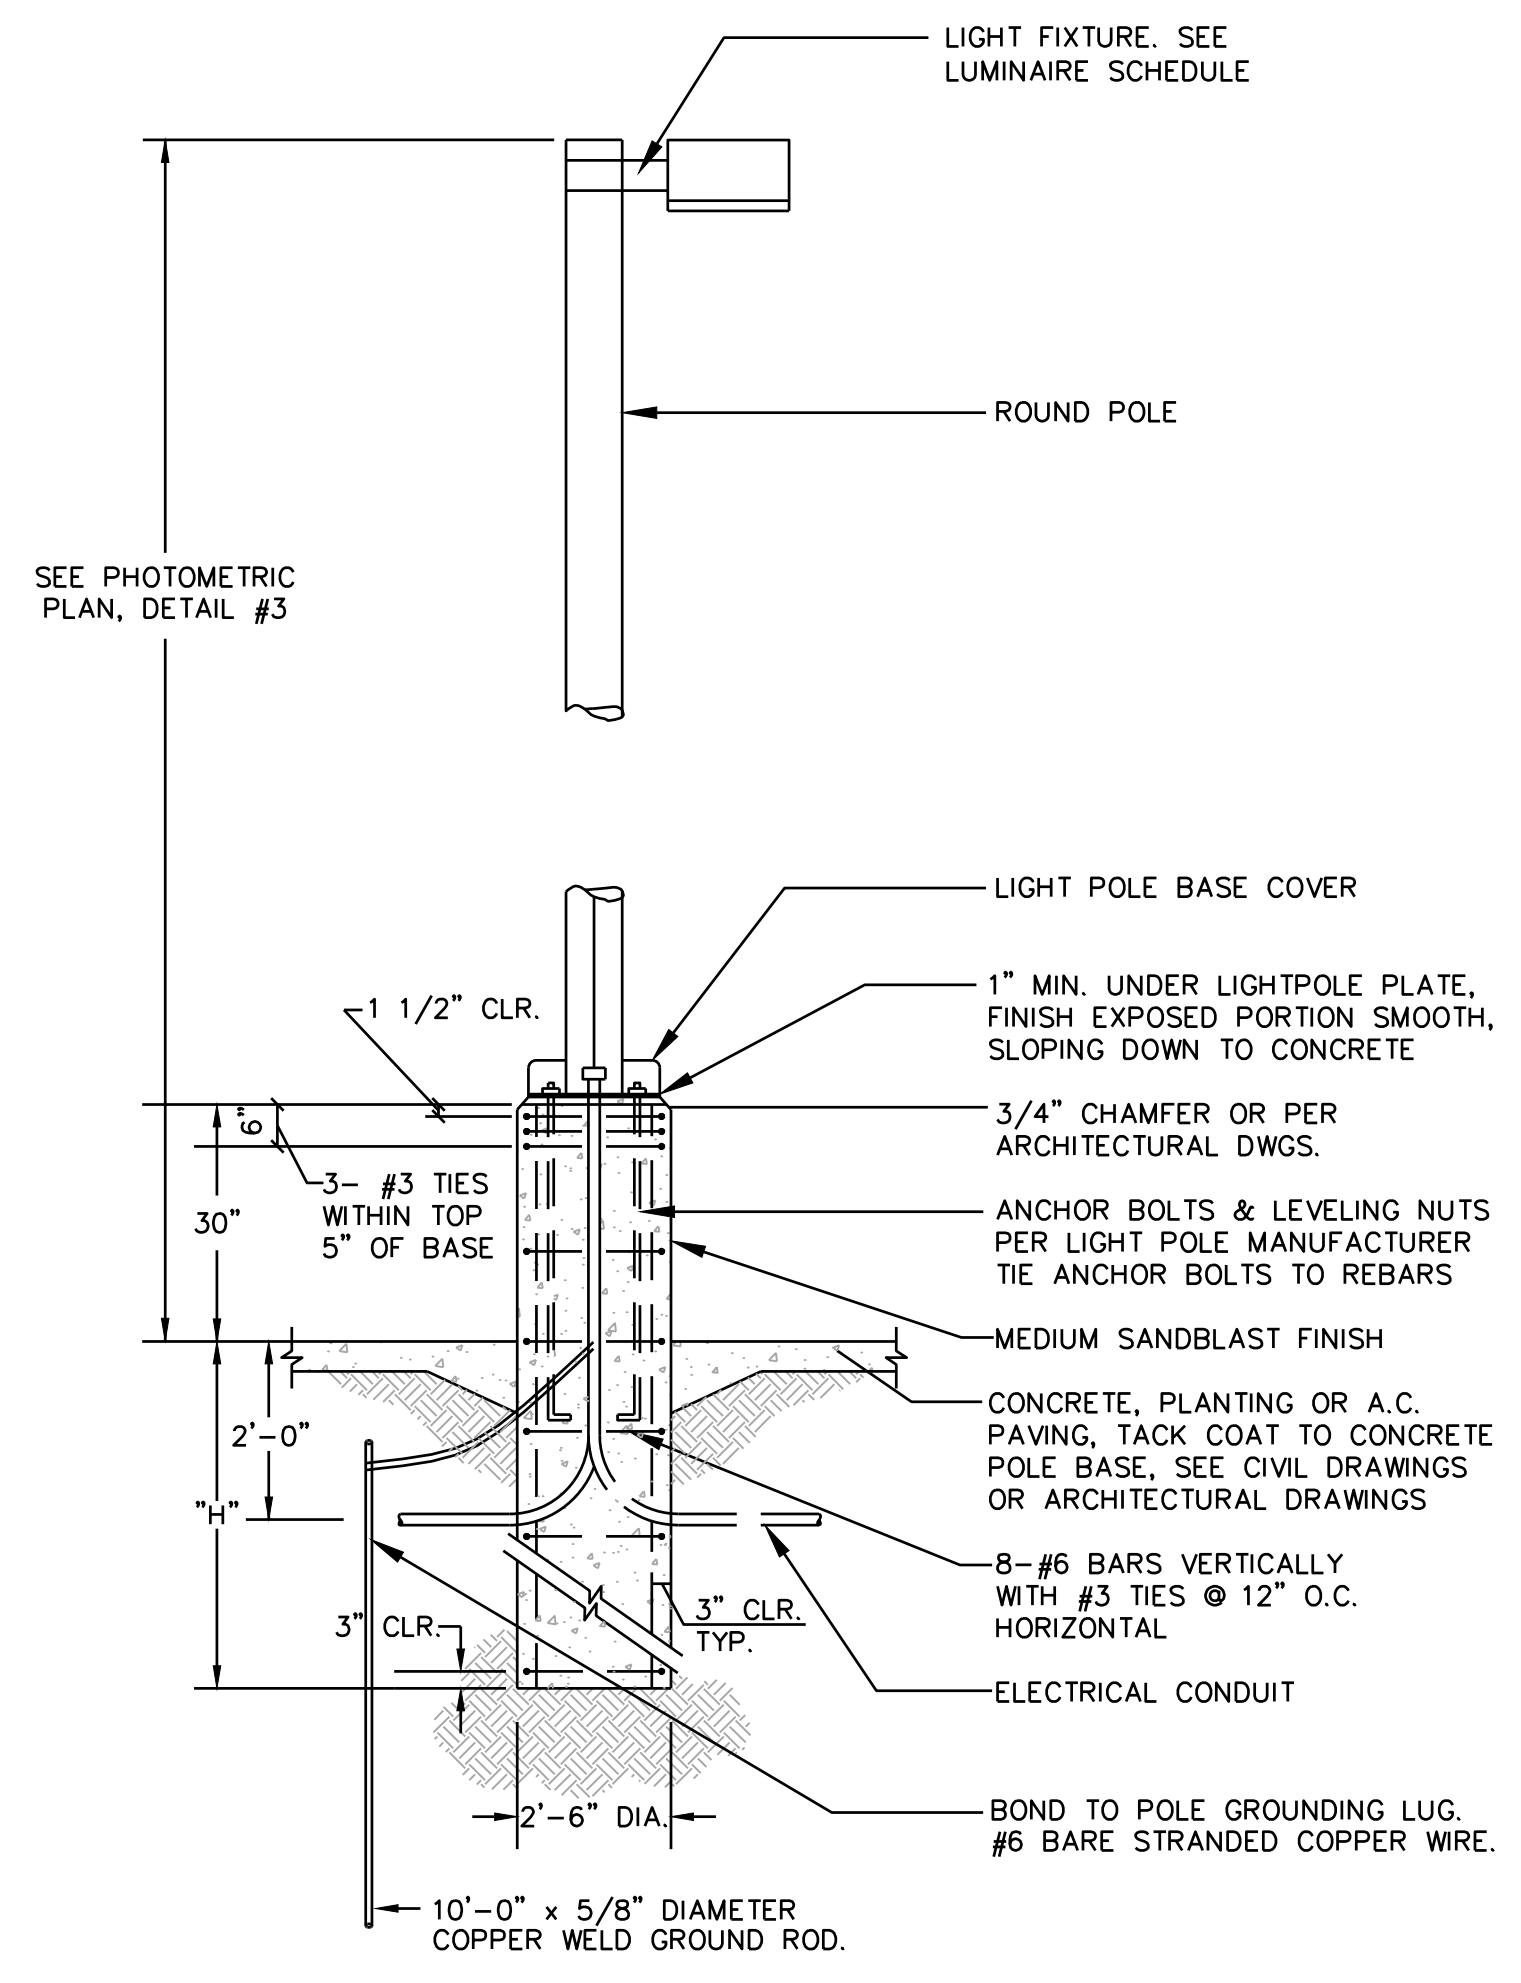

HEIGHT OF POLE ABOVE BASE	"H" WHERE CONCRETE PAVING OCCURS AT BASE	"H" WHERE A.C. PAVING OR PLANTING OCCURS AT BASE
40' - 44'	9'-0"	7'-6"
36' - 40'	6'-0"	7'-0"
31' - 35'	5'-6"	6'-6"
25' - 30'	5'-0"	6'-0"
20' - 24'	4'-6"	5'-6"
16' - 19'	4'-0"	5'-6"
14' - 15'	4'-0"	5'-0"
10' - 13'	4'-0"	4'-6"

[illegible]

Statistics						
Description	Symbol	Avg	Max	Min	Max/Min	Avg/Min
Loading Dock	+	6.2 fc	9.4 fc	3.1 fc	3.0:1	2.0:1
Parking Lot	+	1.0 fc	6.1 fc	0.1 fc	61.0:1	10.0:1



LIGHTING FIXTURE SCHEDULE AND PHOTOMETRIC DATA	SCALE	2
	NTS	

LIGHT POLE DETAILS	SCALE	1
	NTS	