
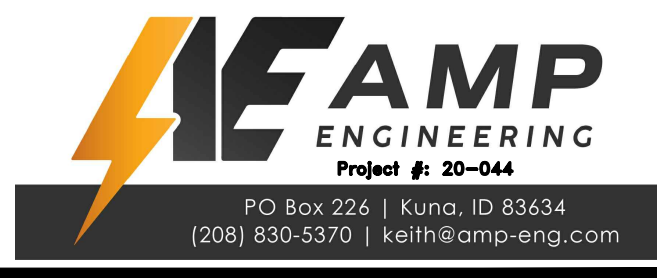


1 EXTERIOR LIGHTING PLAN
1" = 30'-0"

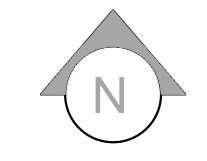

No.	Revision/Issue
<p>valley design</p> <p>230 W AVENIDA VALENCIA, SAN CLEMENTE CA. 92672 (909)576-5659</p>	
<p>SHEET TITLE</p> <p>EXTERIOR LIGHTING PLAN</p>	
CLIENT	AD FACILITY INDIAN AVENUE DESERT HOT SPRINGS, CA
SCALE:	AS NOTED
DATE:	04/14/2020
DRAWN BY:	KWA
PROJECT NO.:	1942
SHEET NO.:	E101